

GENERAL NOTES:

- FIXTURES ON CIRCUITS FROM PANEL EH4 ARE FED VIA THE GENERATOR THROUGH A TRANSFER SWITCH. ANY AUTOMATIC CONTROLS SHALL DEFAULT TO THE ON POSITION AFTER POWER CYCLE.
- REFER TO ARCHITECTURAL REFLECTED CEILING PLAN AND DETAILS FOR THE LOCATION OF ALL LIGHTING FIXTURES AND ALL OTHER EQUIPMENT INSTALLED IN THE CEILING SYSTEM. VERIFY MOUNTING HEIGHTS AND FINISHES WITH ARCHITECT PRIOR TO ROUGH-IN.
- CONFIRM ALL FIXTURE TYPES WITH INTERIOR DESIGNER PRIOR TO PURCHASE OR ROUGH-IN.
- ELECTRICAL CONTRACTOR IS TO PROVIDE ALL LIGHT FIXTURES. SEE FIXTURE SCHEDULE ON SHEET E009.
- THE NUMBER OF WIRES PER CONDUIT ARE NOT INDICATED ON THE LIGHTING PLAN(S). DO NOT EXCEED CONDUIT FILL CAPACITY WITHOUT DERATING WIRING AMPACITY BASED ON NEC AMPACITY TABLE 310.15(B)(3)(a). PROVIDE DEDICATED NEUTRALS TO FIXTURES INTENDED TO BE DIMMED.
- MOUNT EXIT SIGNS 12" ABOVE DOOR OR ON CEILING, UNLESS OTHERWISE NOTED. ARRANGE DIRECTIONAL ARROWS TO INDICATE DIRECTION OF EXIT, AS REQUIRED.
- FIRE ALARM DEVICES ARE SHOWN FOR INTENT PURPOSES ONLY. CONTRACTOR SHALL PROVIDE A COMPLETE FIRE ALARM SYSTEM, COMPLYING WITH LOCAL CODES / NFPA AND PROVIDE STAMPED DRAWINGS BY A LICENSED FIRE ENGINEER SHOWING DEVICE LOCATIONS AND ALL CALCULATIONS.
- SEE ENLARGED ROOM PLANS ON E301/302 SHEETS FOR EACH TYPICAL GUEST ROOM LAYOUT.

KEY NOTES:


- CONTINUED TO NEXT LEVEL.

STIPULATION FOR REUSE: THIS DRAWING WAS PREPARED FOR USE ON A SPECIFIC SITE AT DULUTH, GA CONTEMPORANEOUSLY WITH ITS ISSUE DATE AS NOTED BELOW. AND IT IS NOT SUITABLE FOR USE ON A DIFFERENT PROJECT SITE OR AT A LATER TIME. USE OF THIS DRAWING FOR REFERENCE OR EXAMPLE IN ANOTHER PROJECT REQUIRES THE SERVICES OF PROPERLY LICENSED ARCHITECTS AND ENGINEERS. REPRODUCTION OF THIS DRAWING FOR REUSE ON ANOTHER PROJECT IS NOT AUTHORIZED AND MAY BE CONTRARY TO THE LAW.



CONSULTANTS:
bes
 Beach Engineering Solutions Team
 Mechanical, Electrical & Plumbing Engineering
 (678) 665-3280
 Project Number: 23-547

THE STRICKLANDER
 MARRIOTT AUTOGRAPH
 GUESTROOMS
 6405 SUGARLOAF PARKWAY
 DULUTH, GEORGIA 30097

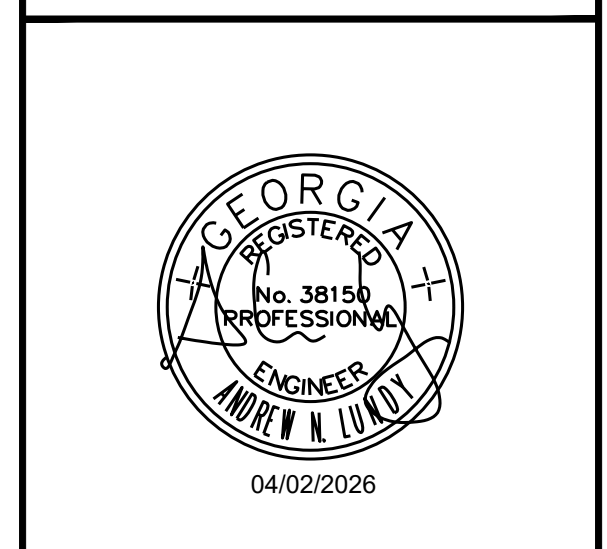

ISSUE BLOCK:

△ CITY REVISIONS	11/22/24
△ REV #4	05/28/25
△ REV #5	04/02/26

DOCUMENT DATE: 10/25/24
 DRAWN BY:
 CHECKED BY:
 PROJECT NO.: JHD-024-NA-100001
 SHEET TITLE:

ELECTRICAL
 OVERALL CEILING
 PLAN - LEVEL 3

SHEET NUMBER:
E-103

1 ELECTRICAL OVERALL CEILING PLAN - LEVEL 3
 SCALE: 1/8" = 1'-0"