


STIPULATION FOR REUSE:
 THIS DRAWING WAS PREPARED FOR USE ON A SPECIFIC SITE AT DULUTH, GA CONTEMPORANEOUSLY WITH ITS ISSUE DATE AS NOTED BELOW, AND IT IS NOT SUITABLE FOR USE ON A DIFFERENT PROJECT SITE OR AT A LATER TIME. USE OF THIS DRAWING FOR REFERENCE OR EXAMPLE ON ANOTHER PROJECT REQUIRES THE SERVICES OF PROPERLY LICENSED ARCHITECTS AND ENGINEERS. REPRODUCTION OF THIS DRAWING FOR REUSE ON ANOTHER PROJECT IS NOT AUTHORIZED AND MAY BE CONTRARY TO THE LAW.

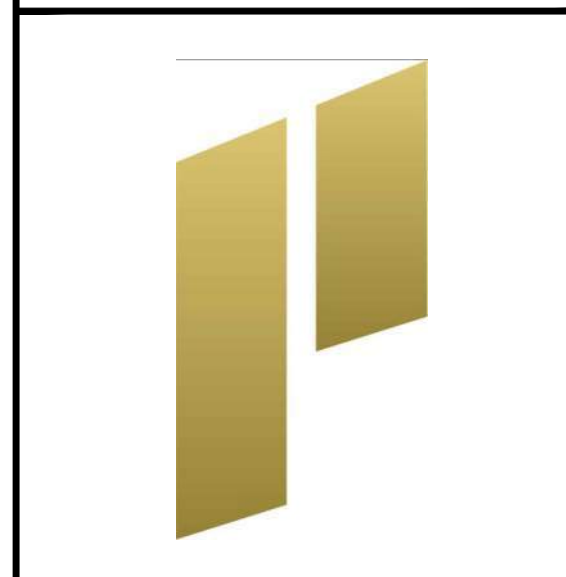

CONSULTANTS:
Beach Engineering Solutions Team
 Mechanical, Electrical & Plumbing Engineering
 (678) 665-3280
 Project Number: 23-547

THE STRICKLANDER
MARRIOTT AUTOGRAPH
GUESTROOMS
 6405 SUGARLOAF PARKWAY
 DULUTH, GEORGIA 30097




ISSUE BLOCK:

1	REV 1	11.22.2024
2	REV 2	04.07.2025
3	REV 3	04.18.2025
4	REV 4	05.28.2025
5	REV 5	04.02.2026

DOCUMENT DATE: 04/02/26
 DRAWN BY: CL/YC
 CHECKED BY: BGB
 PROJECT NO.: JHD-024-NA-100001
 SHEET TITLE:

PLUMBING OVERALL FLOOR PLAN - LEVEL 5

SHEET NUMBER:
P-107

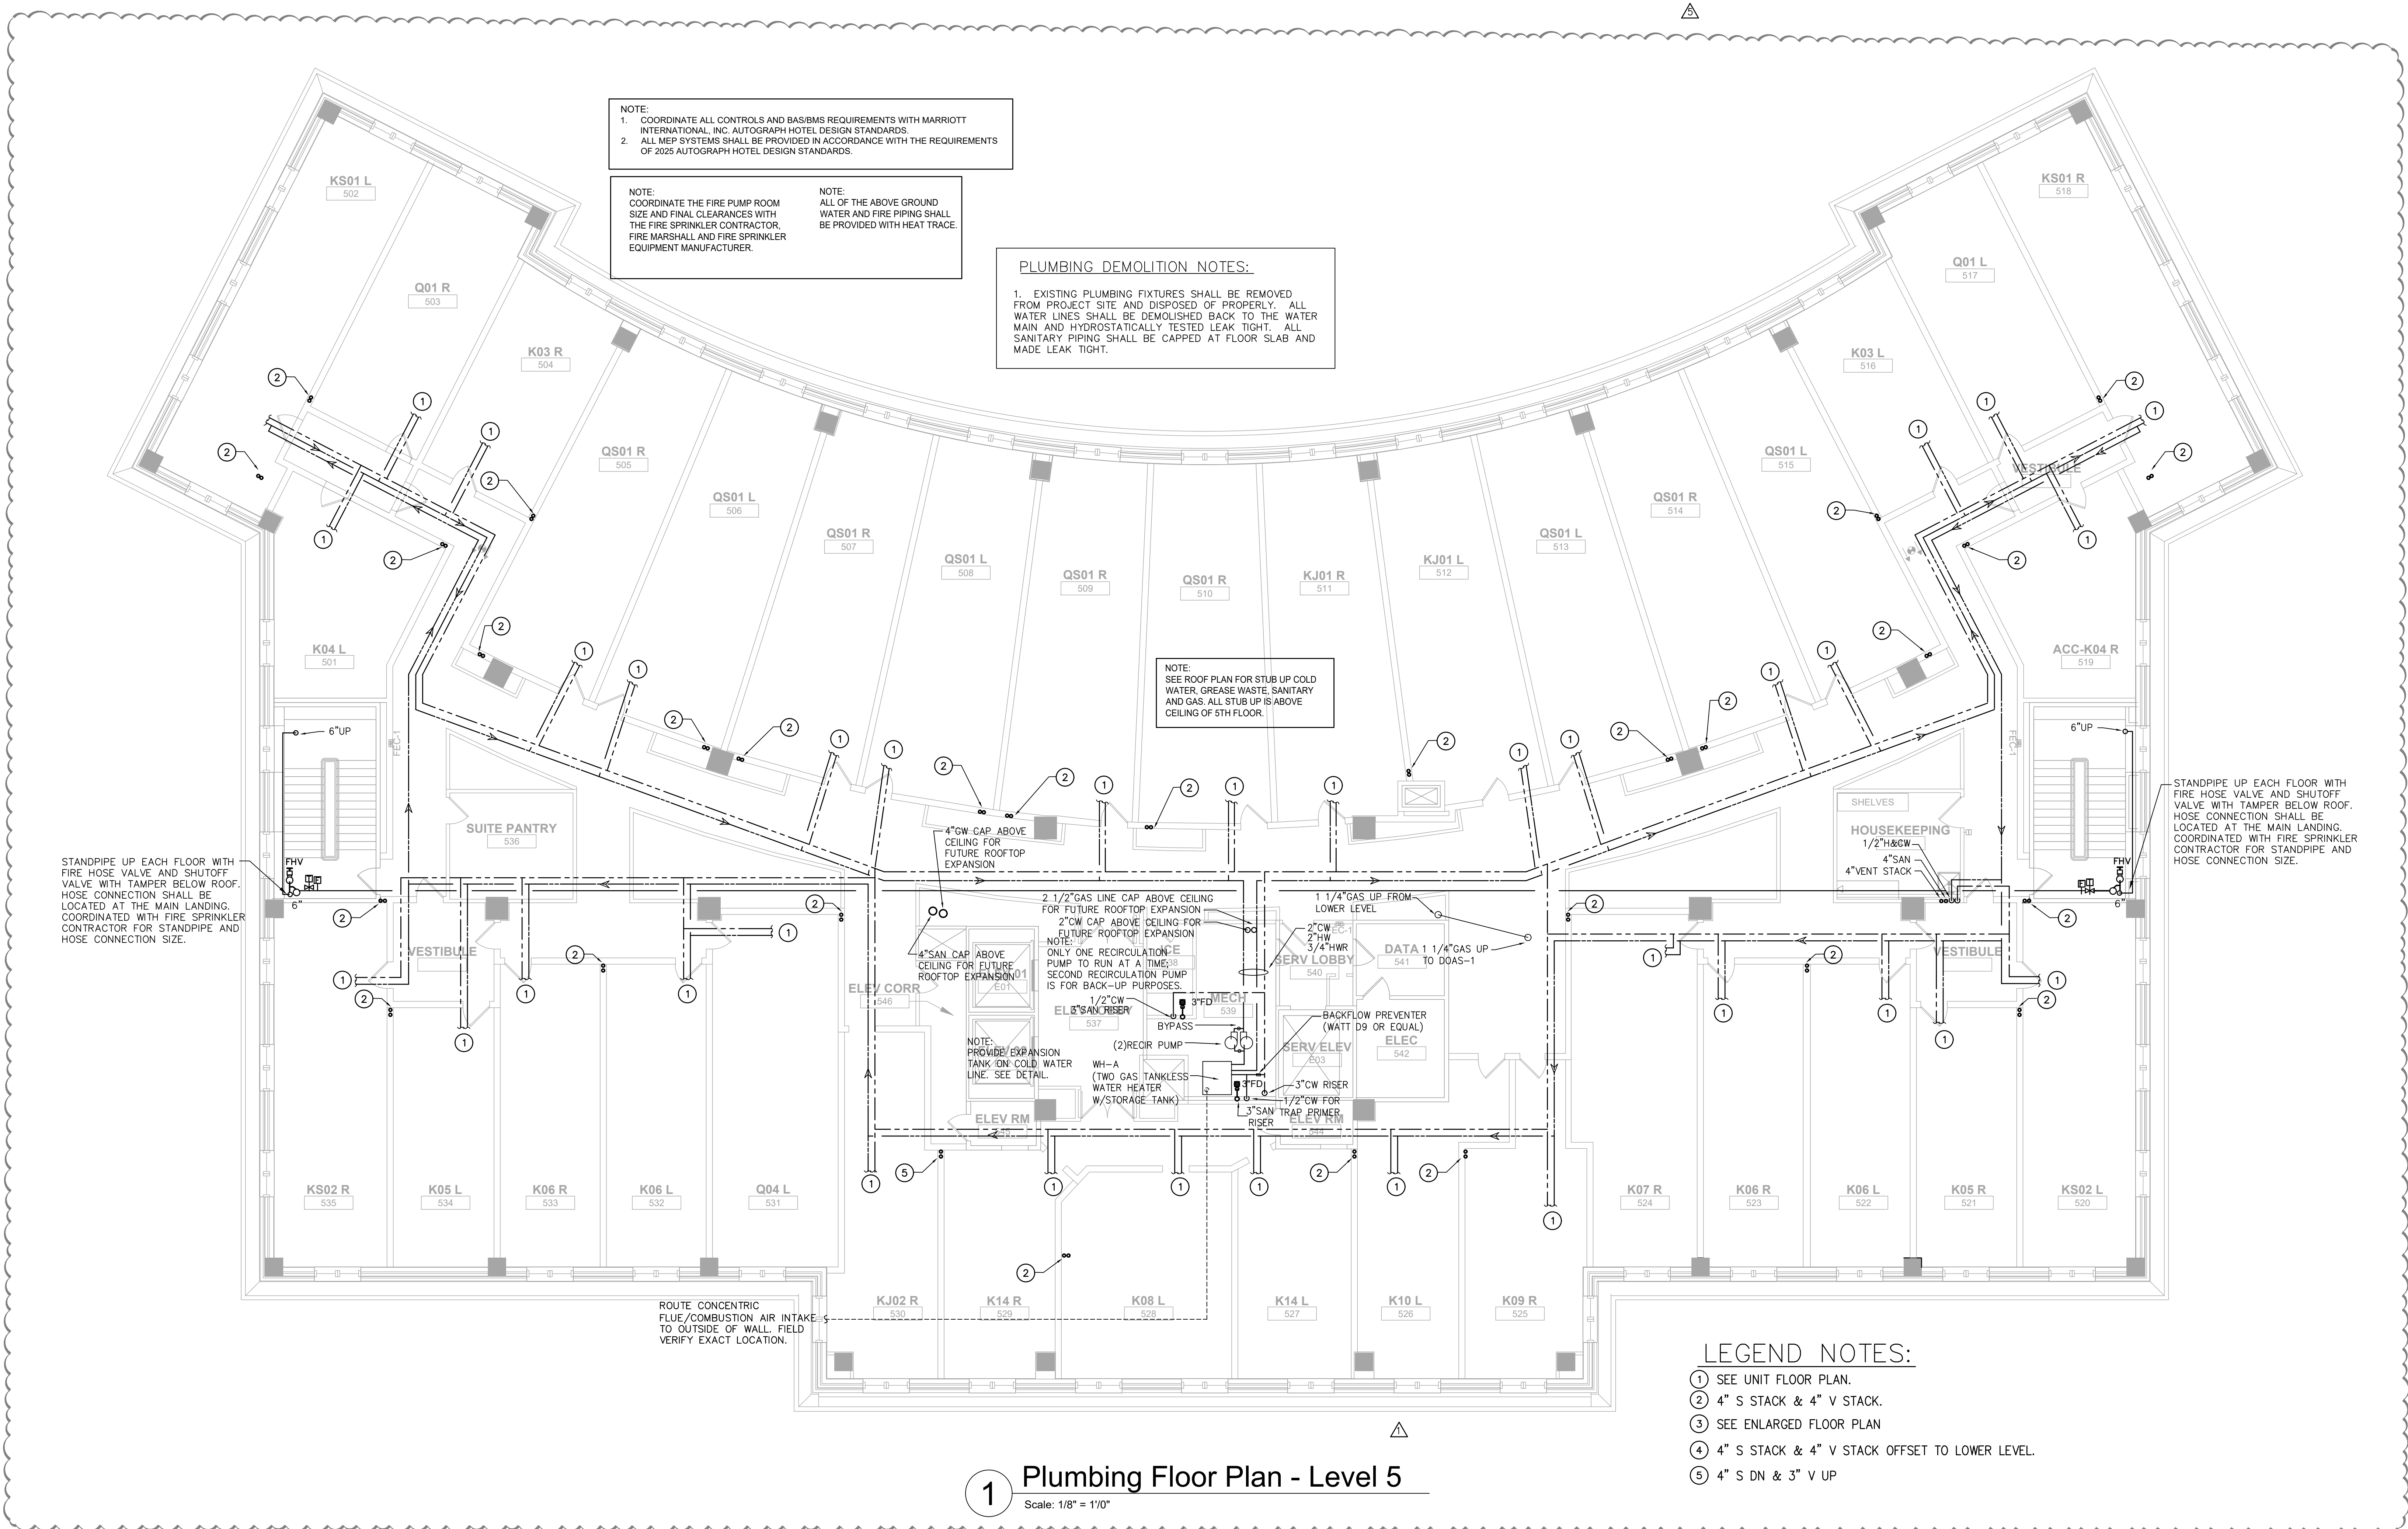

NOTE:
 1. COORDINATE ALL CONTROLS AND BASISMS REQUIREMENTS WITH MARRIOTT INTERNATIONAL, INC. AUTOGRAPH HOTEL DESIGN STANDARDS.
 2. ALL MEP SYSTEMS SHALL BE PROVIDED IN ACCORDANCE WITH THE REQUIREMENTS OF 2025 AUTOGRAPH HOTEL DESIGN STANDARDS.

NOTE:
 COORDINATE THE FIRE PUMP ROOM SIZE AND FINAL CLEARANCES WITH THE FIRE SPRINKLER CONTRACTOR, FIRE MARSHALL AND FIRE SPRINKLER EQUIPMENT MANUFACTURER.

NOTE:
 ALL OF THE ABOVE GROUND WATER AND FIRE PIPING SHALL BE PROVIDED WITH HEAT TRACE.

PLUMBING DEMOLITION NOTES:
 1. EXISTING PLUMBING FIXTURES SHALL BE REMOVED FROM PROJECT SITE AND DISPOSED OF PROPERLY. ALL WATER LINES SHALL BE DEMOLISHED BACK TO THE WATER MAIN AND HYDROSTATICALLY TESTED LEAK TIGHT. ALL SANITARY PIPING SHALL BE CAPPED AT FLOOR SLAB AND MADE LEAK TIGHT.

NOTE:
 SEE ROOF PLAN FOR STUB UP COLD WATER, GREASE WASTE, SANITARY AND GAS. ALL STUB UP IS ABOVE CEILING OF 5TH FLOOR.

STANDPIPE UP EACH FLOOR WITH FIRE HOSE VALVE AND SHUTOFF VALVE WITH TAMPER BELOW ROOF. HOSE CONNECTION SHALL BE LOCATED AT THE MAIN LANDING. COORDINATED WITH FIRE SPRINKLER CONTRACTOR FOR STANDPIPE AND HOSE CONNECTION SIZE.

STANDPIPE UP EACH FLOOR WITH FIRE HOSE VALVE AND SHUTOFF VALVE WITH TAMPER BELOW ROOF. HOSE CONNECTION SHALL BE LOCATED AT THE MAIN LANDING. COORDINATED WITH FIRE SPRINKLER CONTRACTOR FOR STANDPIPE AND HOSE CONNECTION SIZE.

LEGEND NOTES:
 1 SEE UNIT FLOOR PLAN.
 2 4" S STACK & 4" V STACK.
 3 SEE ENLARGED FLOOR PLAN
 4 4" S STACK & 4" V STACK OFFSET TO LOWER LEVEL.
 5 4" S DN & 3" V UP

1 Plumbing Floor Plan - Level 5
 Scale: 1/8" = 1'0"