

STIPULATION FOR REUSE:  
 THIS DRAWING WAS PREPARED FOR USE ON A SPECIFIC SITE AT DULUTH, GA CONTEMPORANEOUSLY WITH ITS ISSUE DATE AS NOTED BELOW, AND IT IS NOT SUITABLE FOR USE ON A DIFFERENT PROJECT SITE OR AT A LATER TIME. USE OF THIS DRAWING FOR REFERENCE OR EXAMPLE ON ANOTHER PROJECT REQUIRES THE SERVICES OF PROPERLY LICENSED ARCHITECTS AND ENGINEERS. REPRODUCTION OF THIS DRAWING FOR REUSE ON ANOTHER PROJECT IS NOT AUTHORIZED AND MAY BE CONTRARY TO THE LAW.



CONSULTANTS:  
**Beach Engineering Solutions Team**  
 Mechanical, Electrical & Plumbing Engineering  
 (678) 665-3280  
 Project Number: 23-547

**THE STRICKLANDER**  
**MARRIOTT AUTOGRAPH**  
**GUESTROOMS**  
 6405 SUGARLOAF PARKWAY  
 DULUTH, GEORGIA 30097




ISSUE BLOCK:

1	REV 1	11.22.2024
2	REV 2	04.07.2025
3	REV 3	04.18.2025
4	REV 4	05.28.2025
5	REV 5	04.02.2026

DOCUMENT DATE: 04/02/26  
 DRAWN BY: CL/YC  
 CHECKED BY: BGB  
 PROJECT NO.: JHD-024-NA-100001  
 SHEET TITLE:

**PLUMBING CONDENSATE FLOOR PLAN - LEVEL 3**

SHEET NUMBER:  
**P-110**

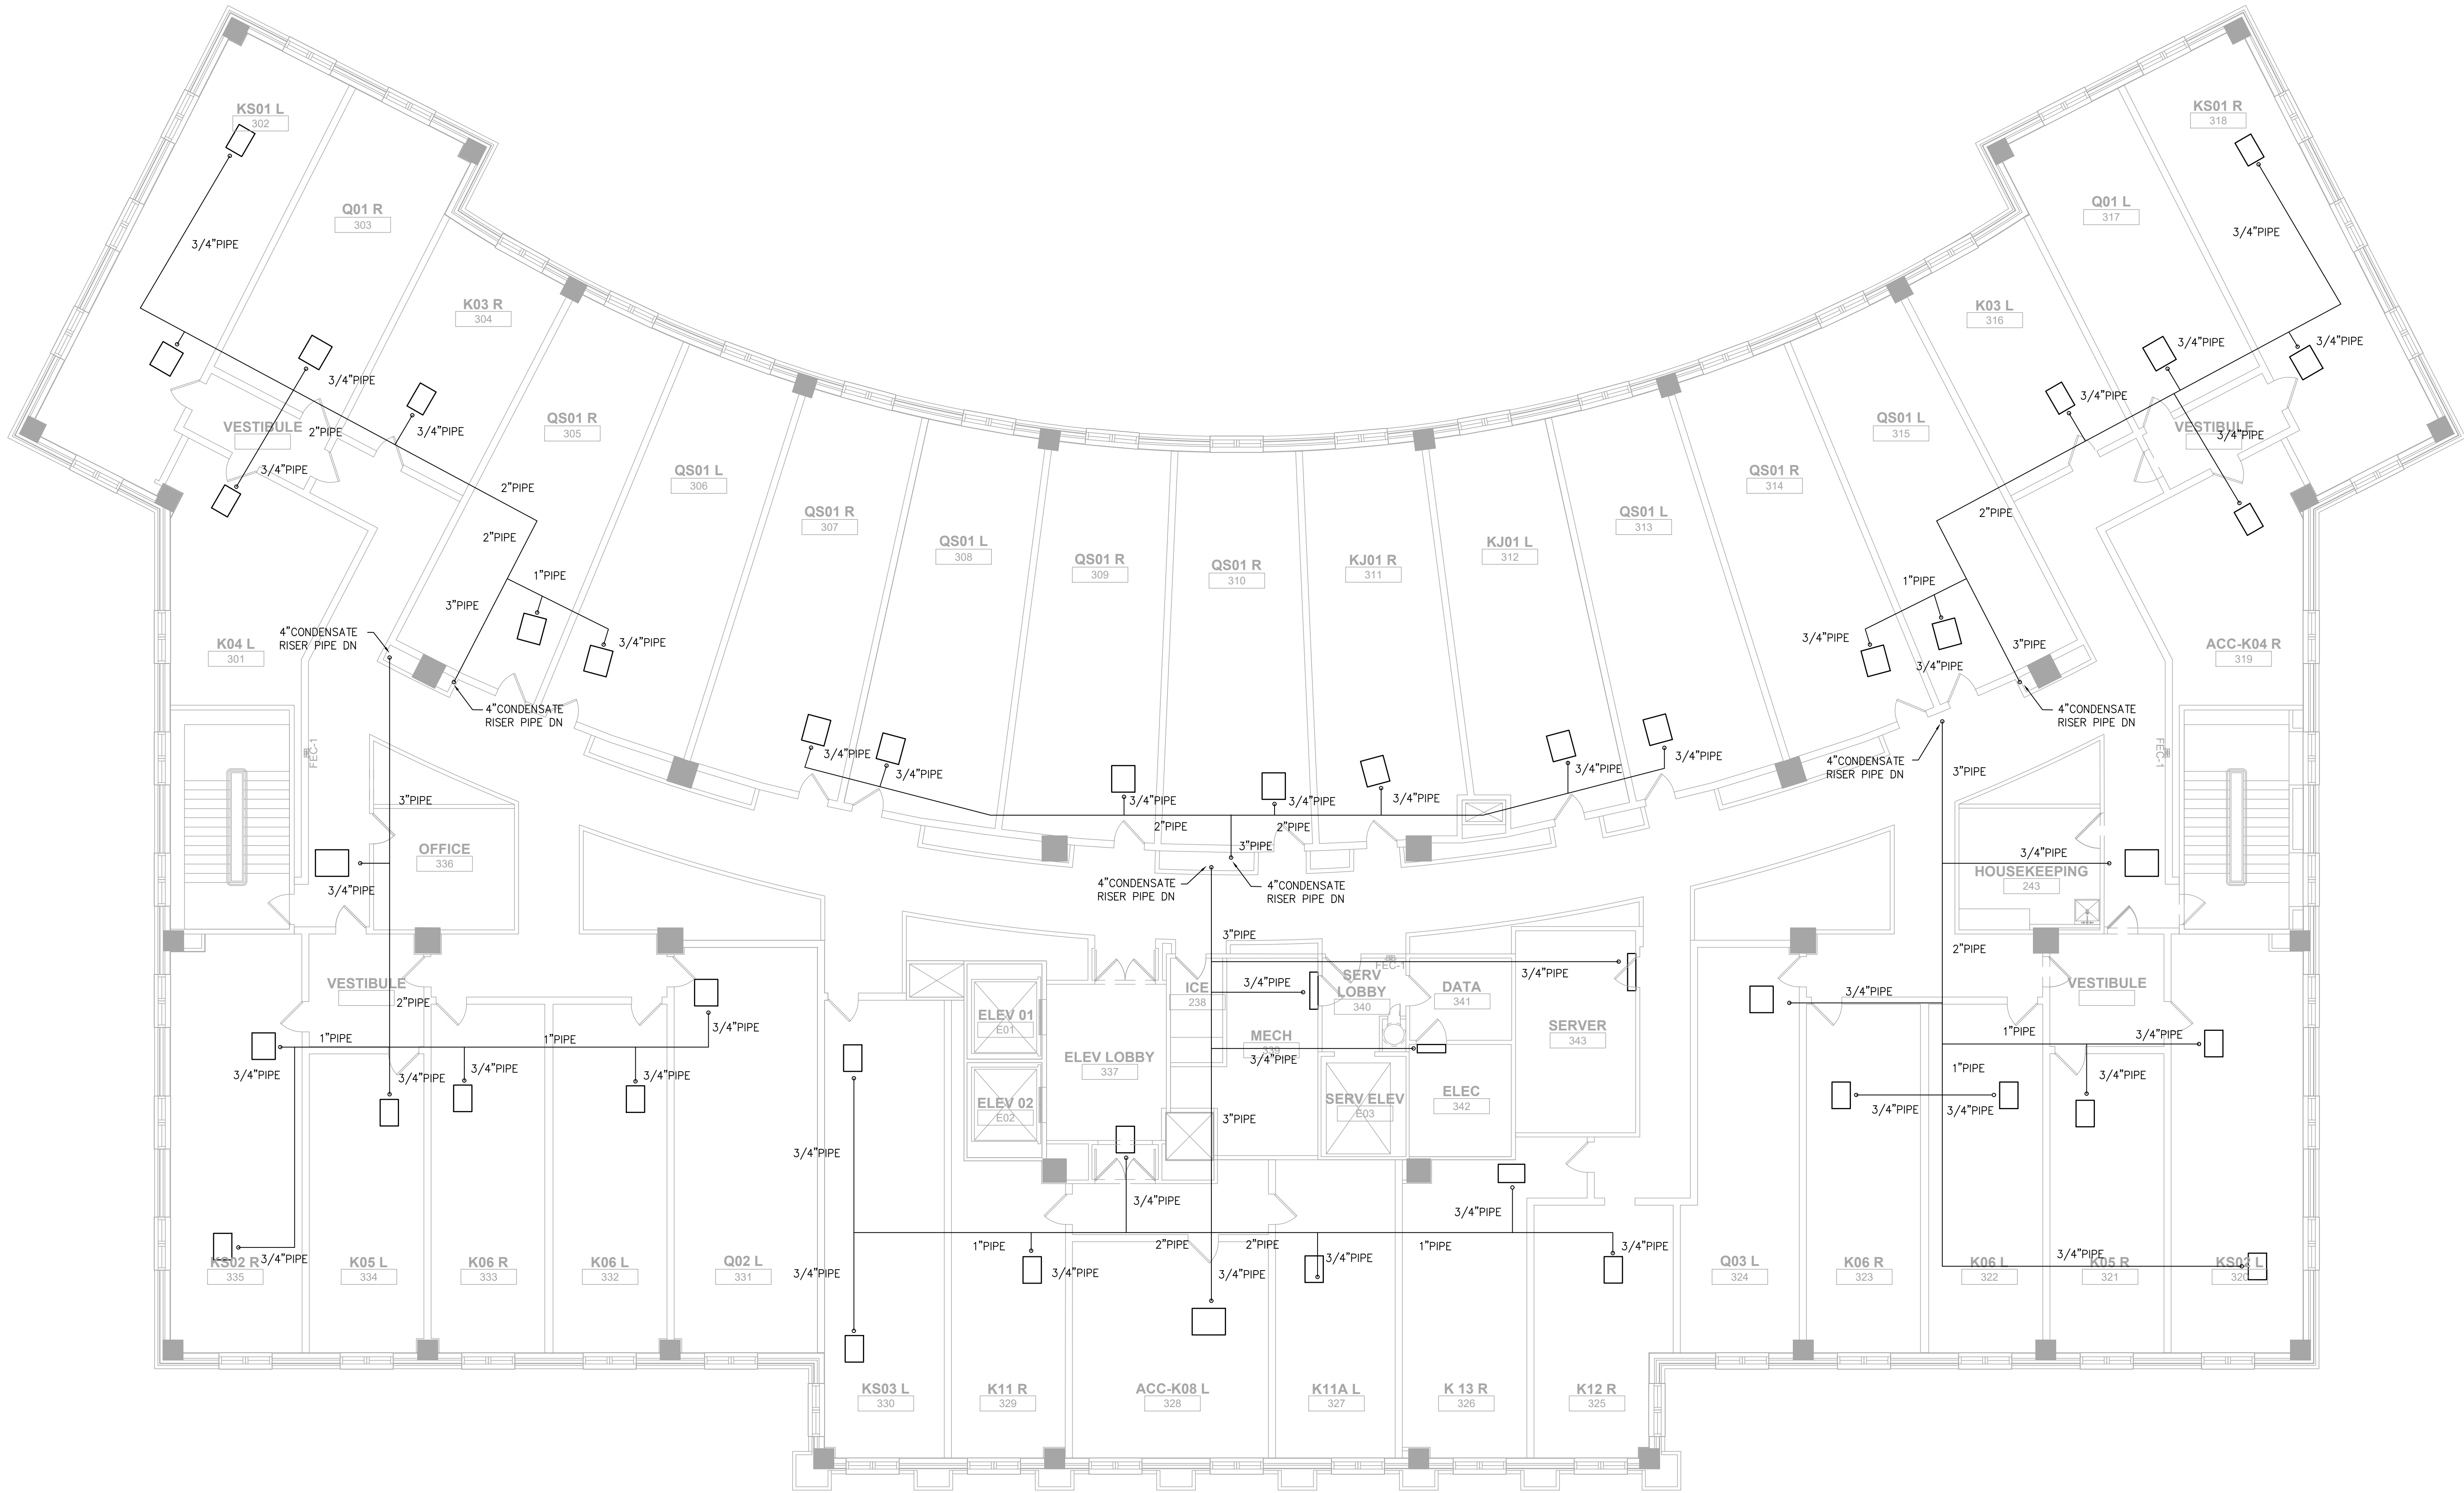

**1** Plumbing Condensate Floor Plan - Level 3  
 Scale: 1/8" = 1'-0"

5

NEW SHEET