




1 KS01 L Typical Guestroom Plan  
SCALE: 1/4" = 1'-0"

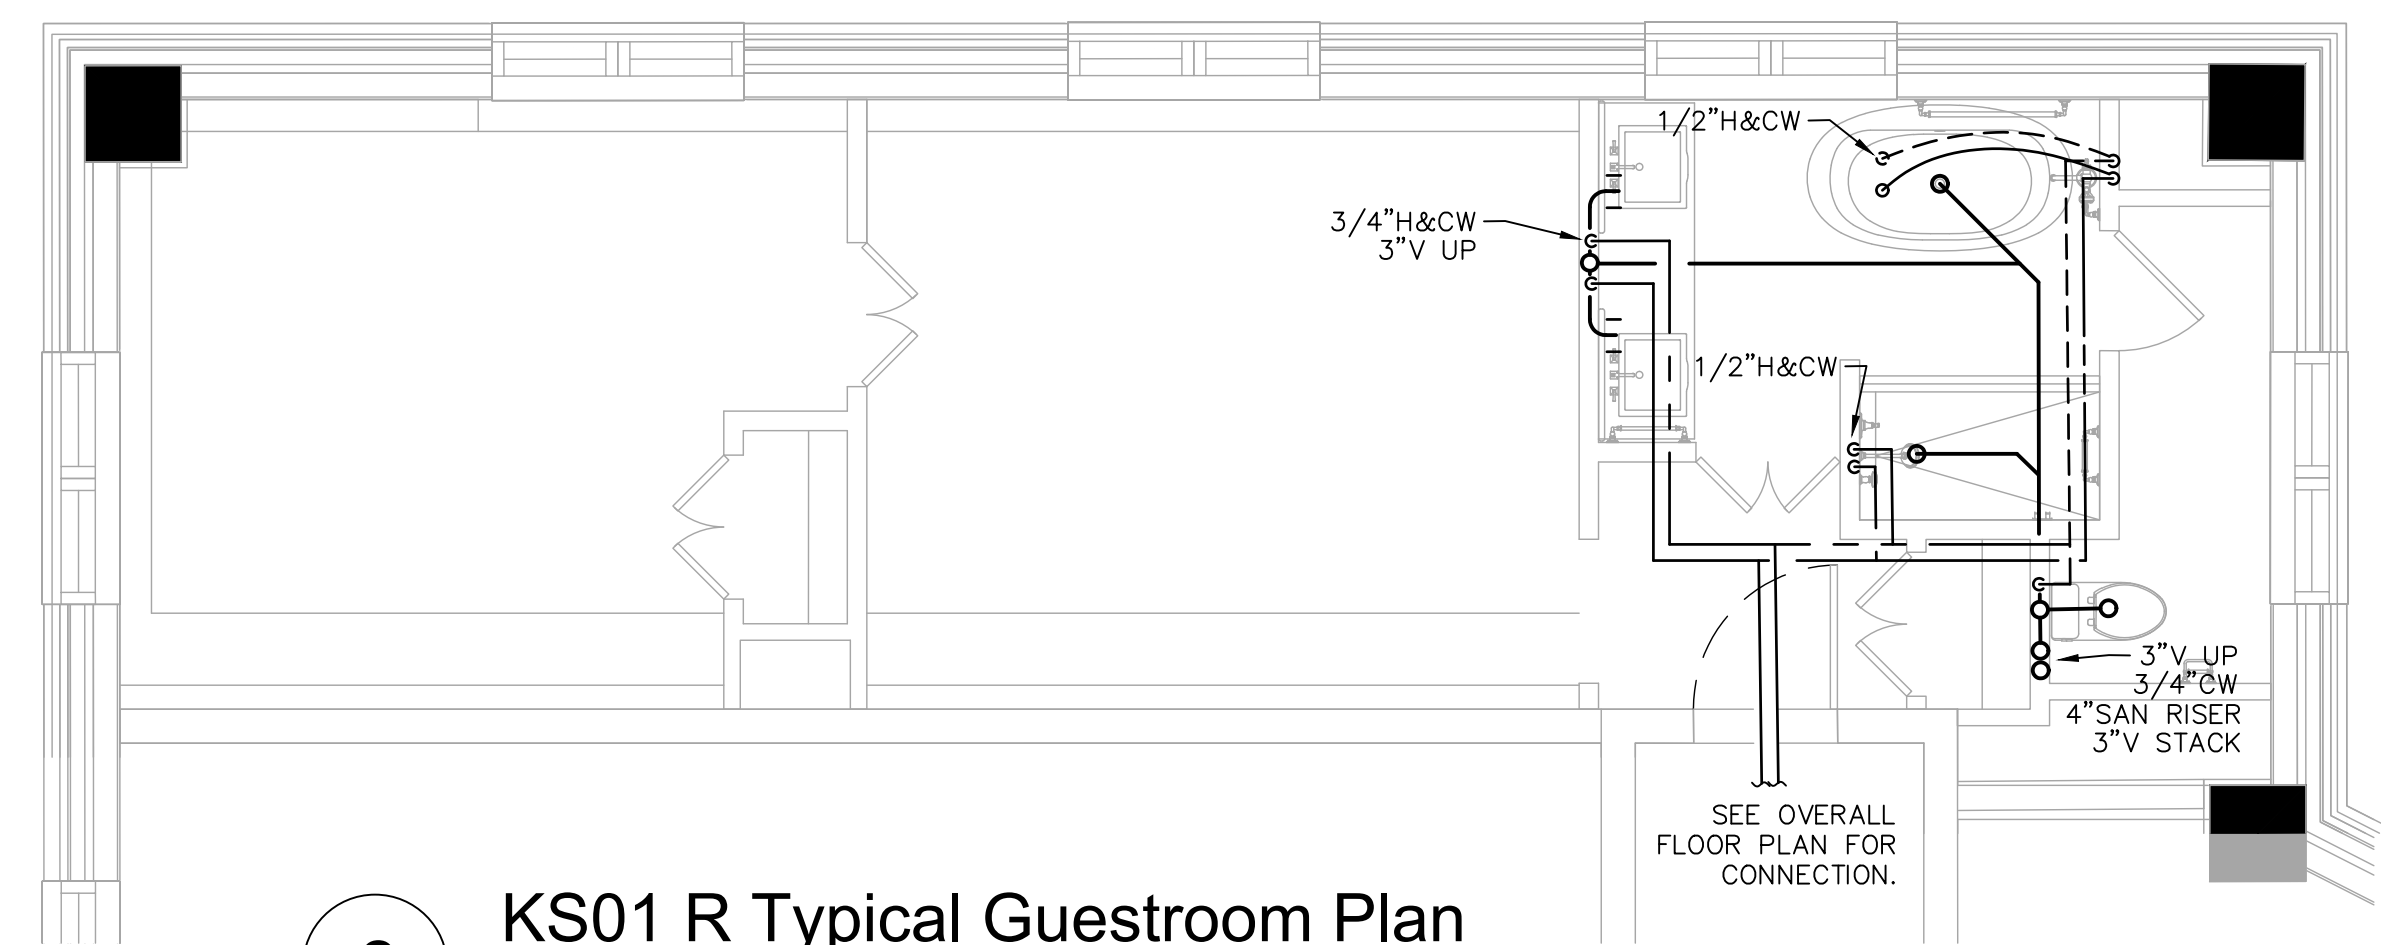


2 KS01 R Typical Guestroom Plan  
SCALE: 1/4" = 1'-0"

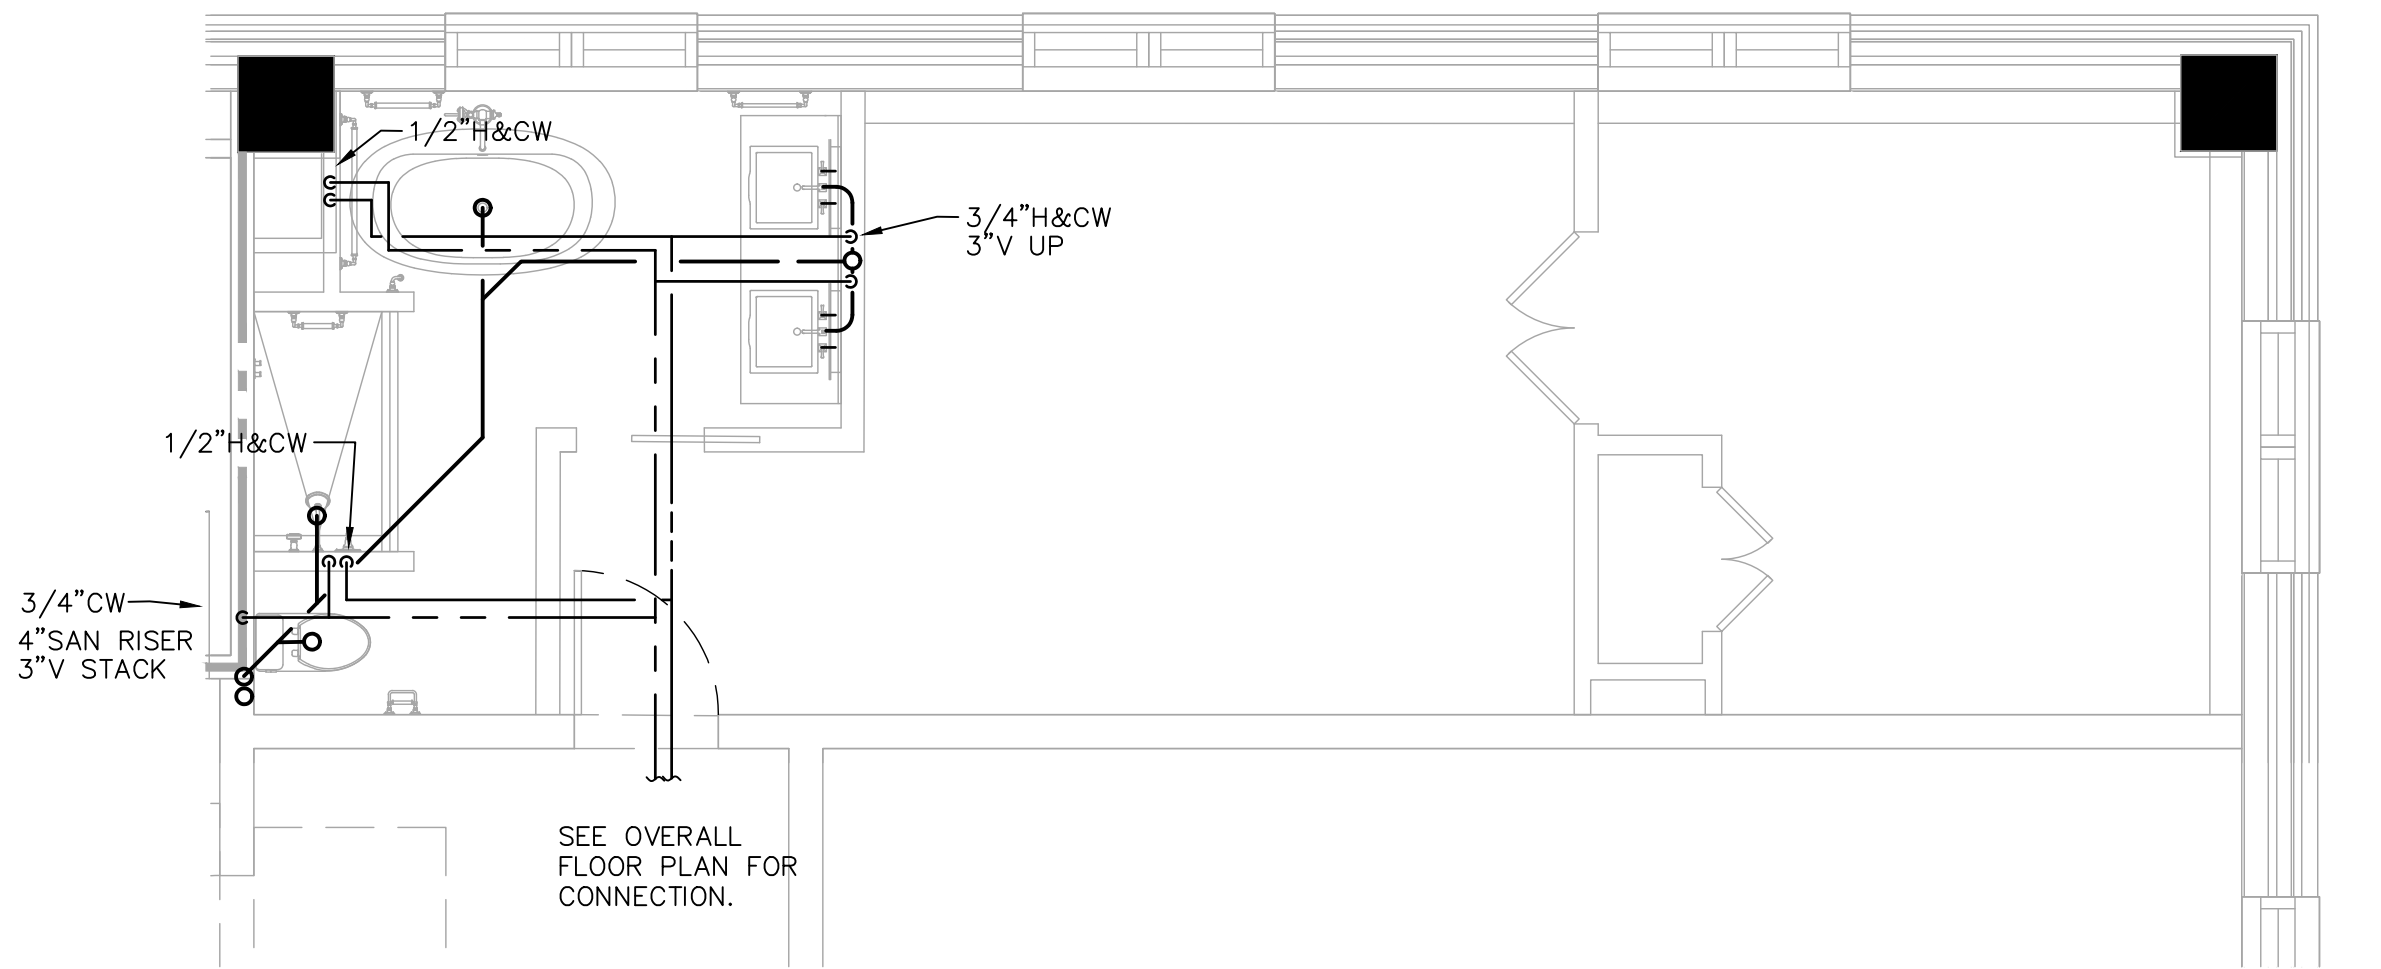


3 KS02 L Typical Guestroom Plan  
SCALE: 1/4" = 1'-0"

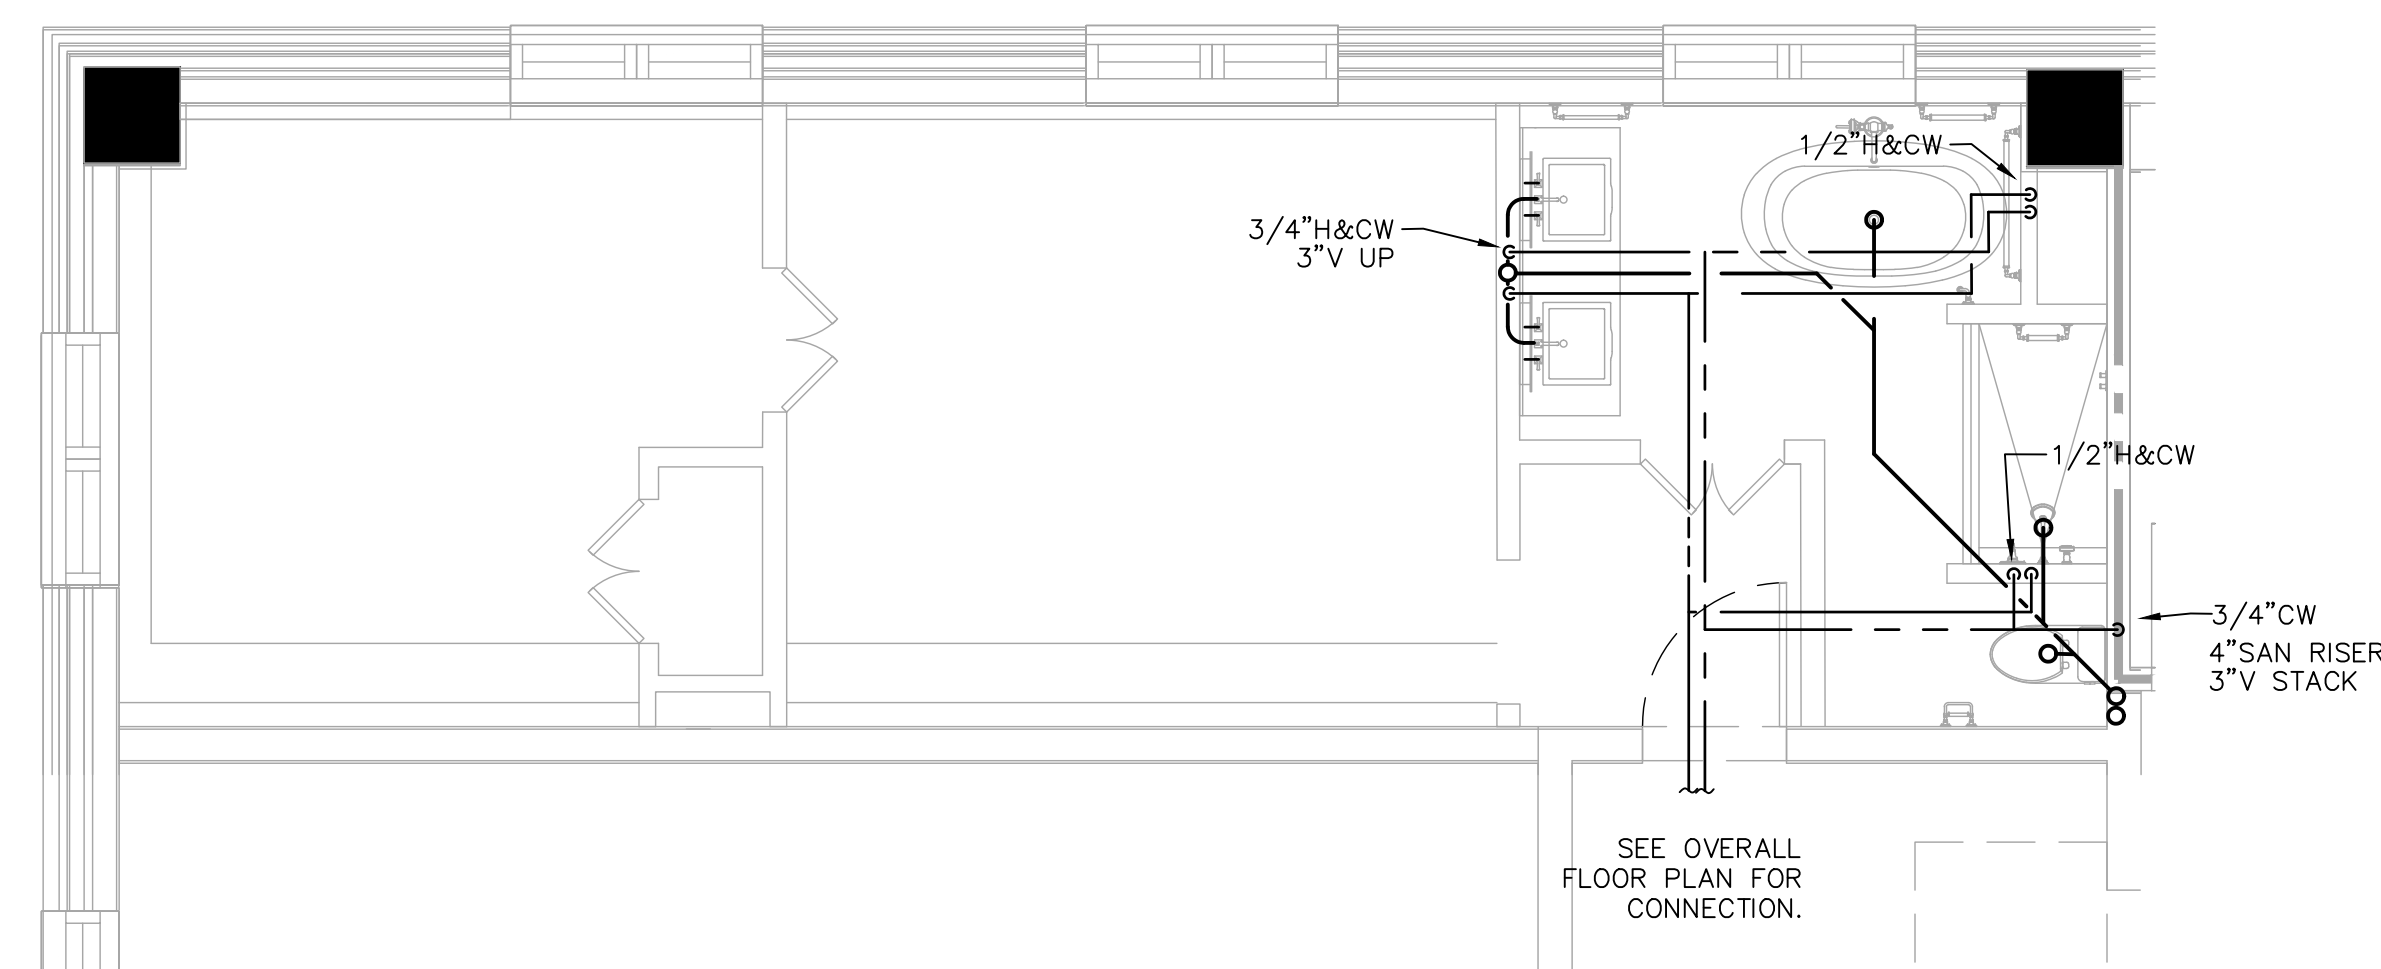


4 KS02 R Typical Guestroom Plan  
SCALE: 1/4" = 1'-0"

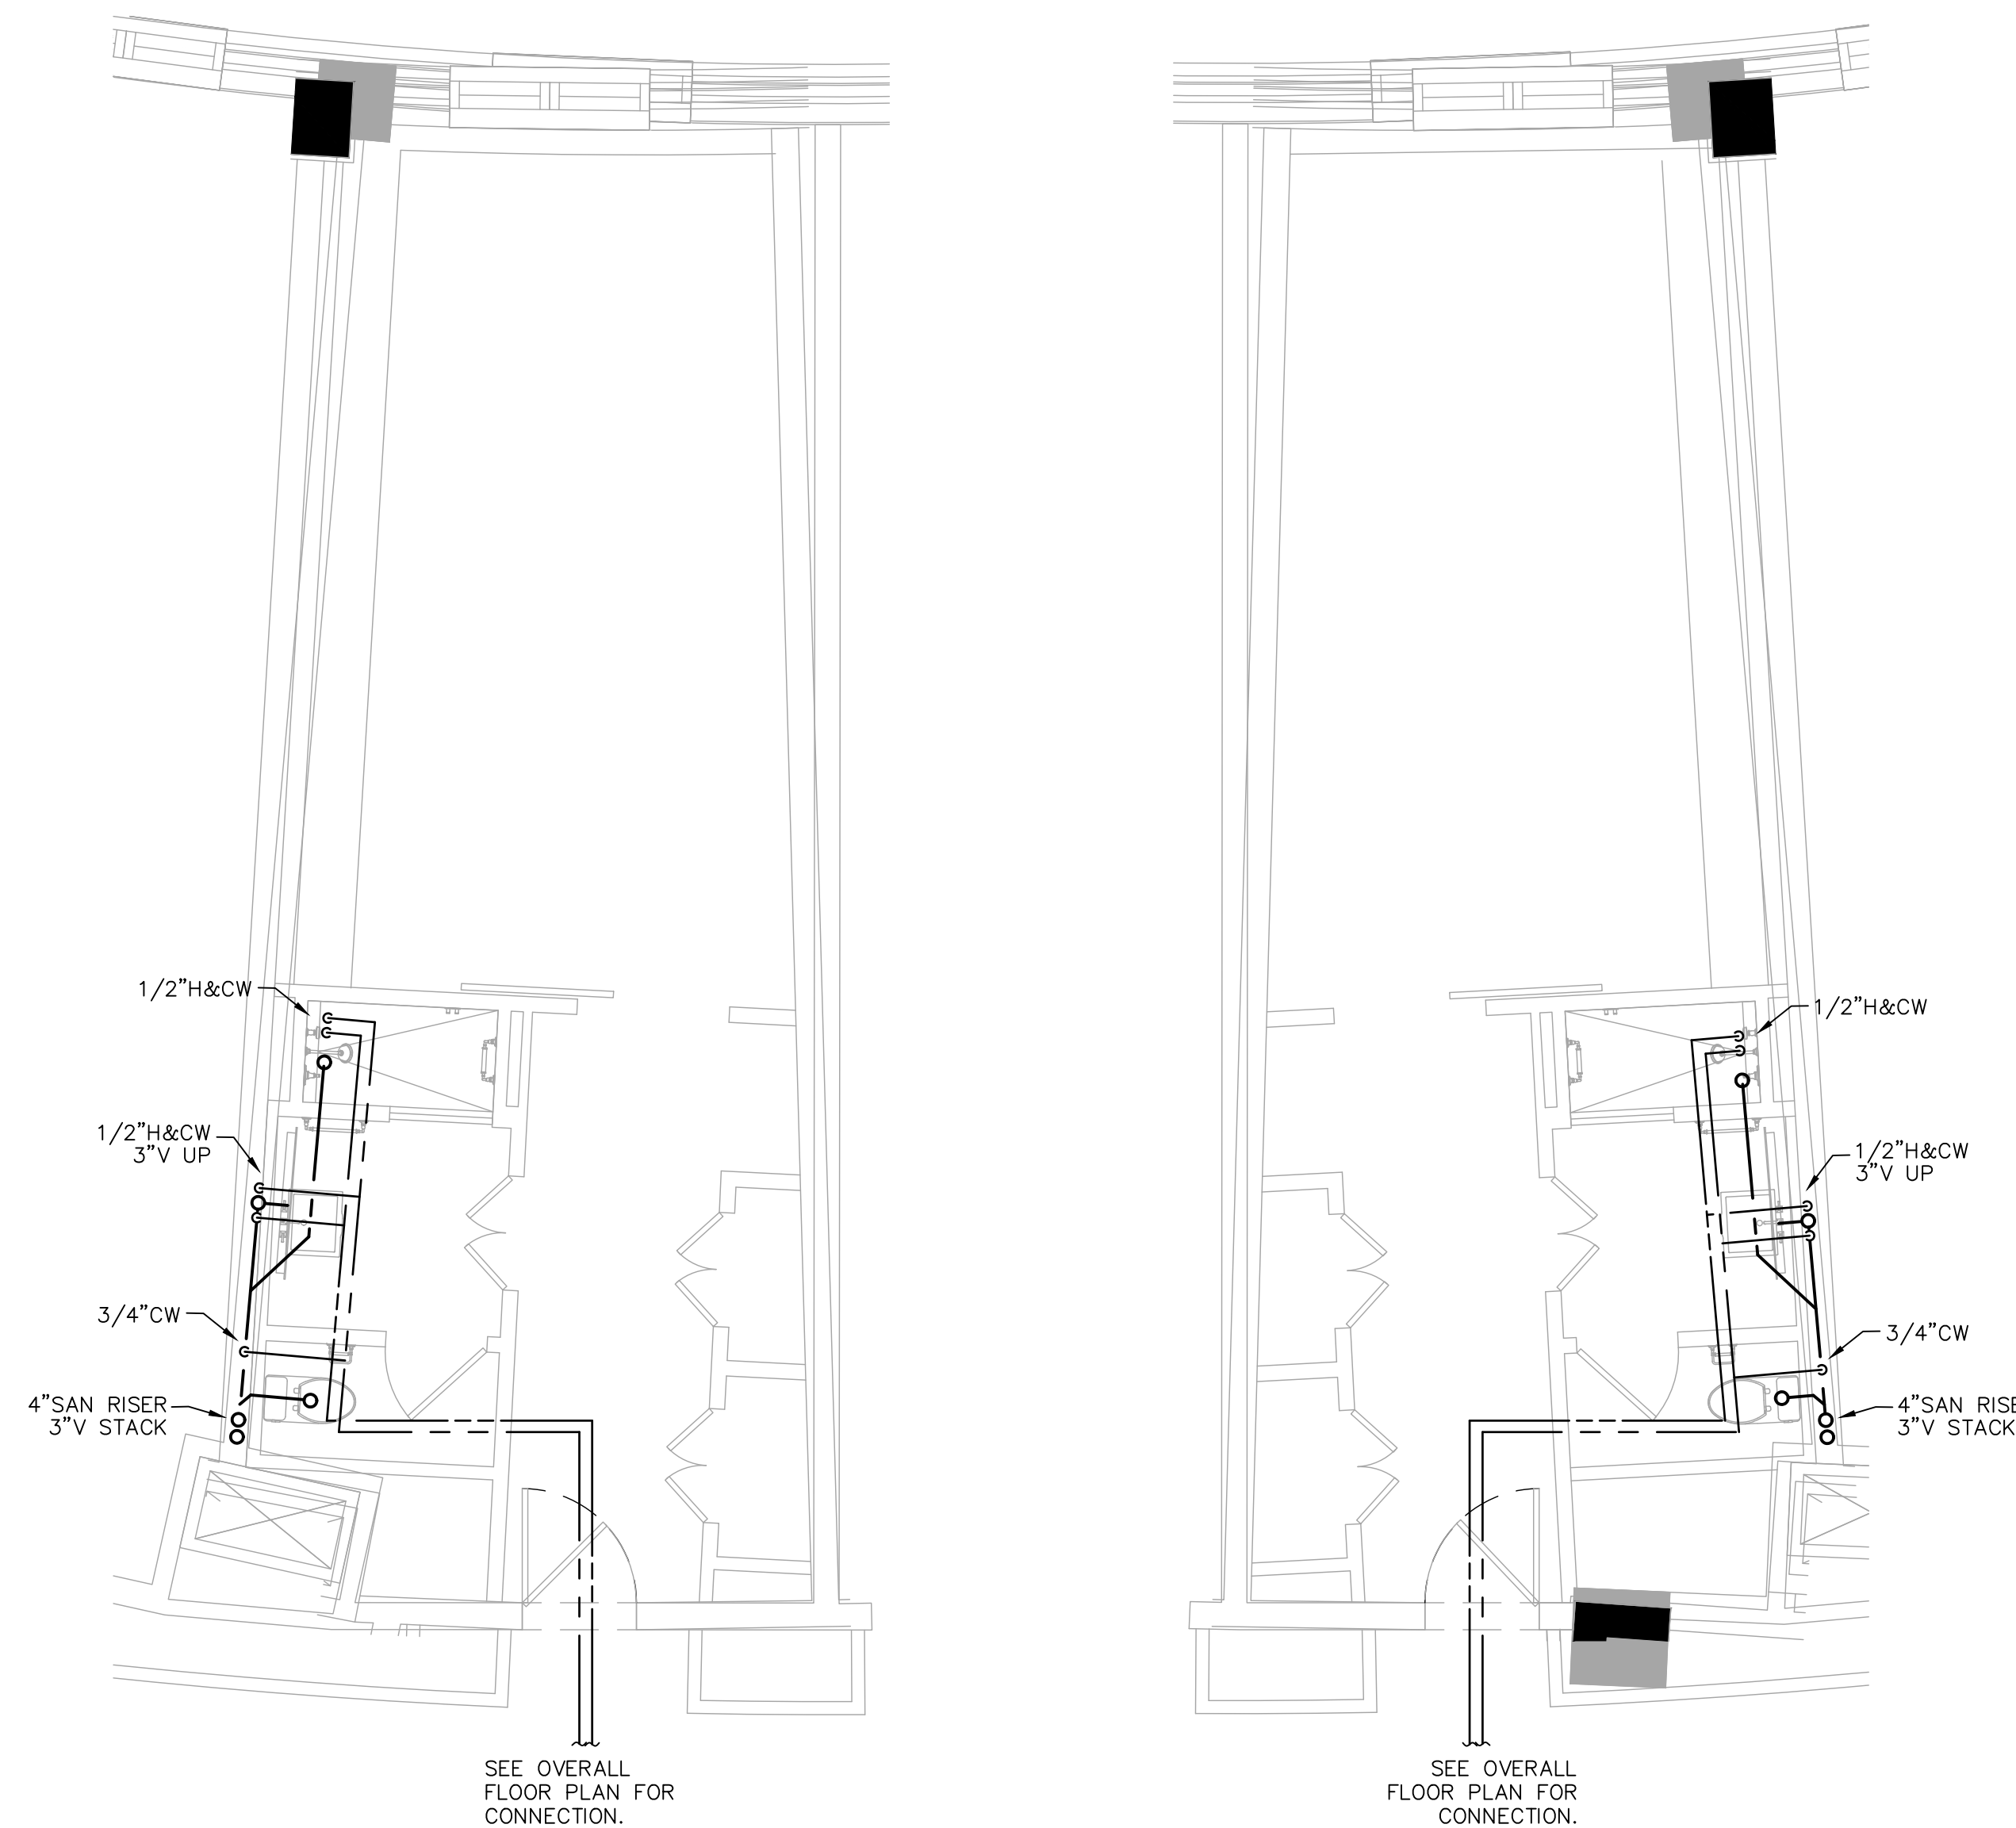


5 KJ01 L Typical Guestroom Plan  
SCALE: 1/4" = 1'-0"

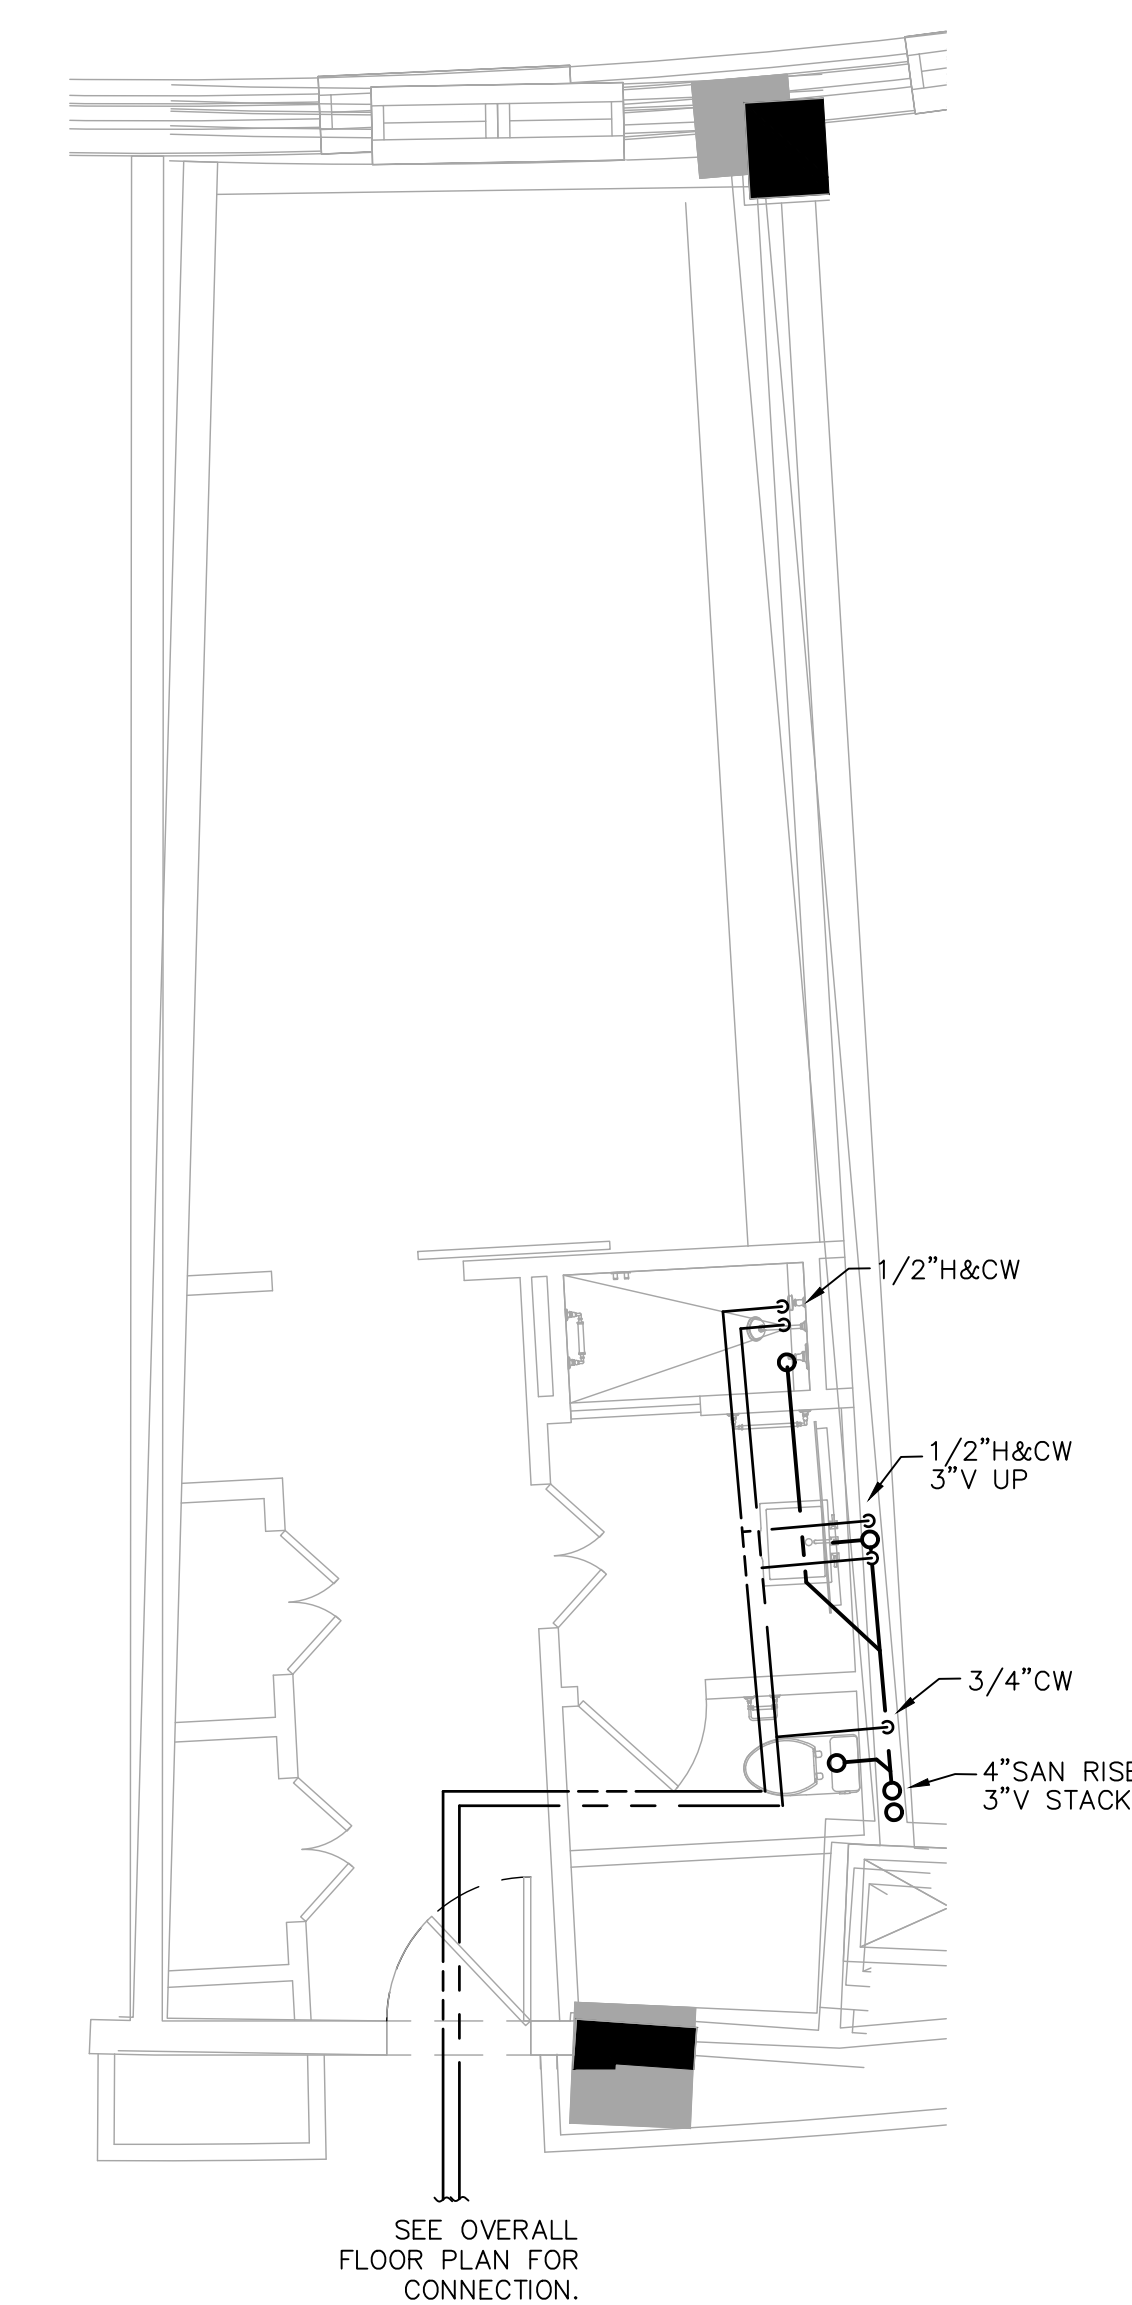


6 KJ01 R Typical Guestroom Plan  
SCALE: 1/4" = 1'-0"

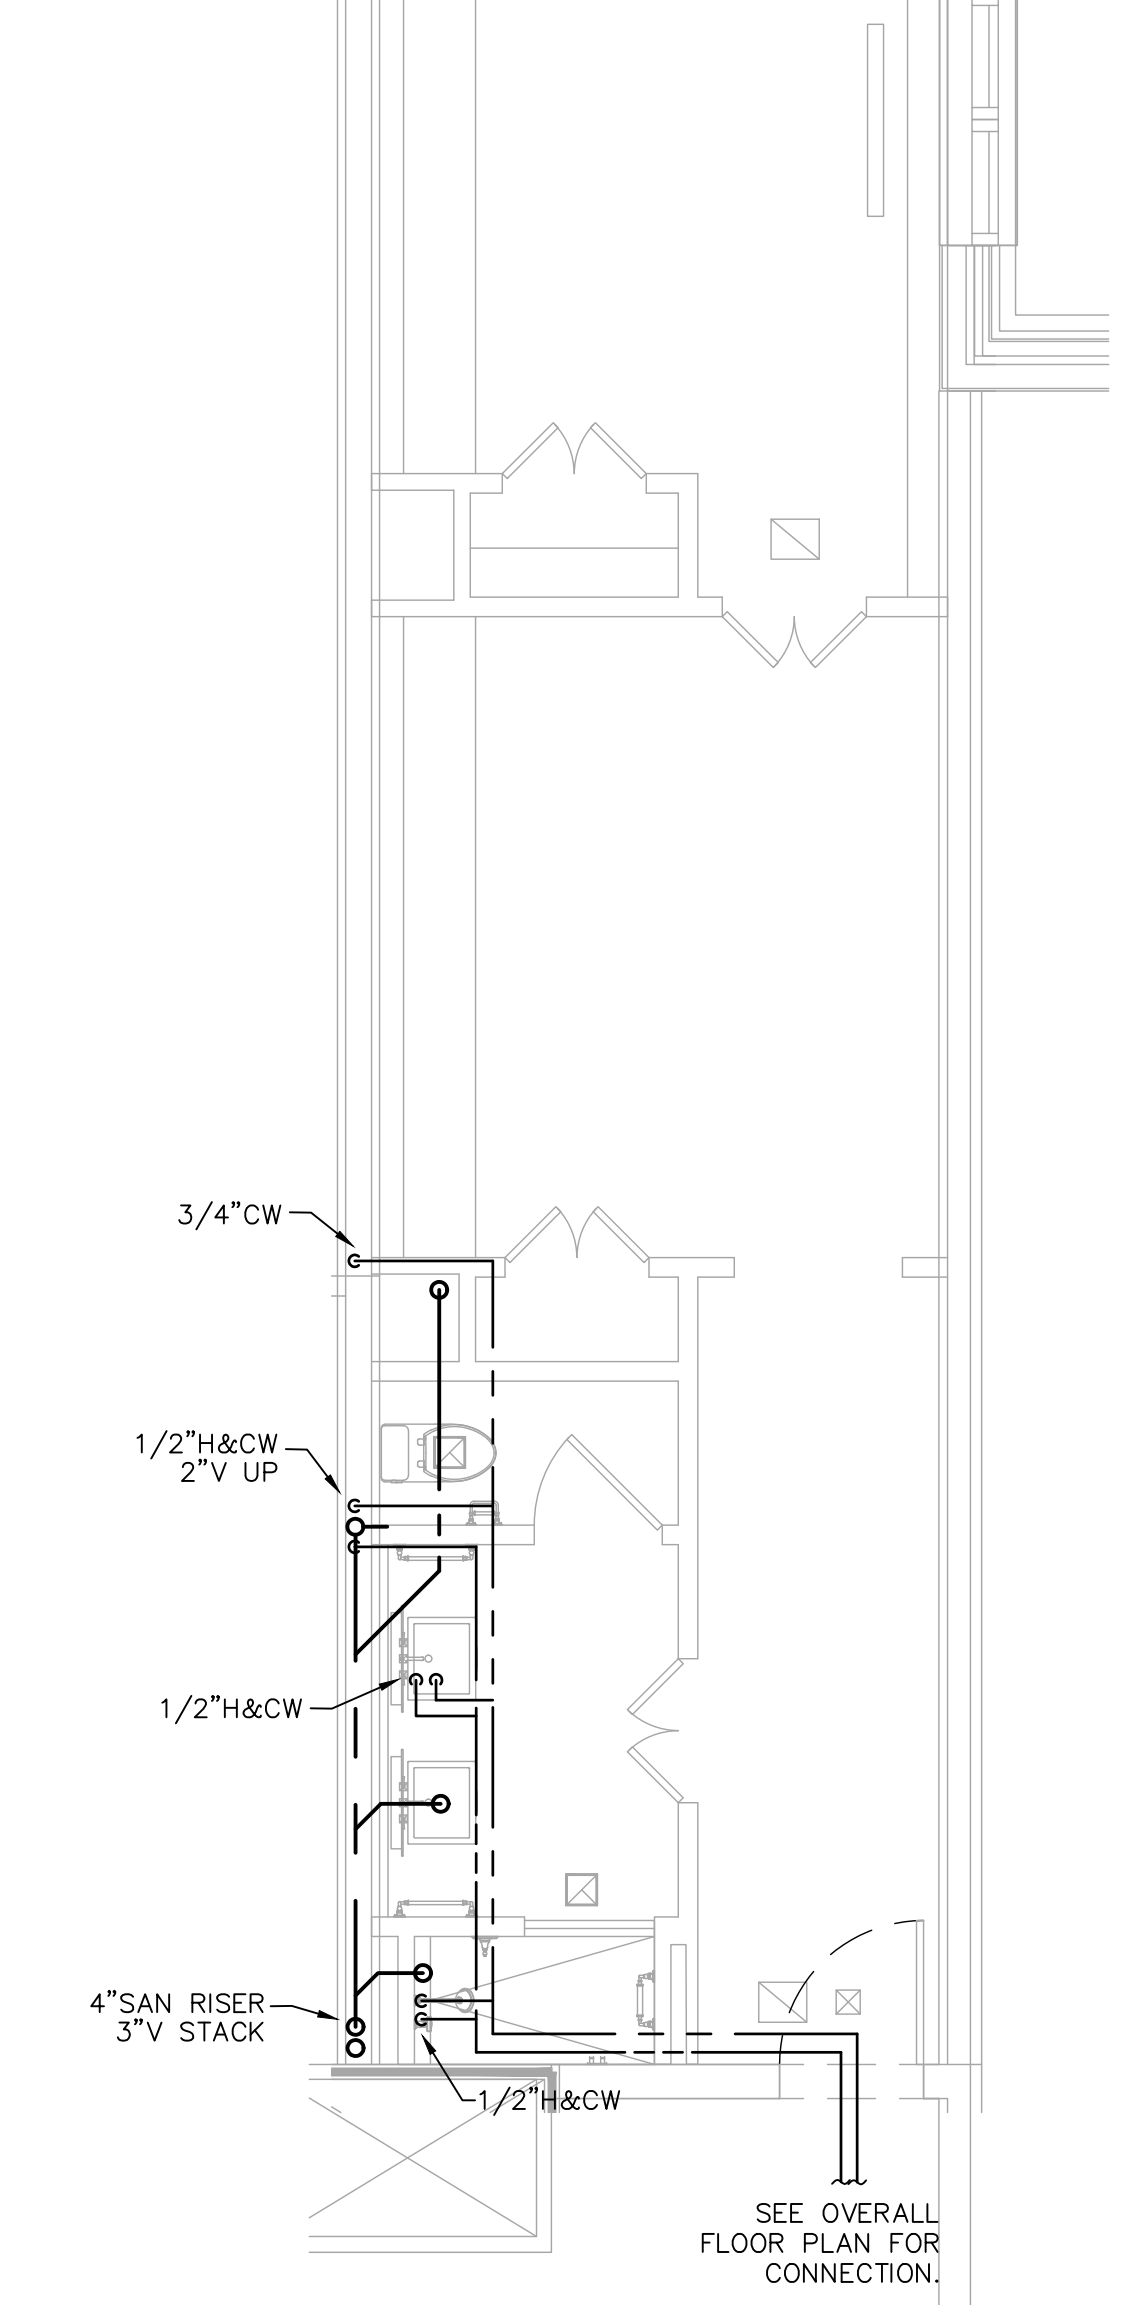


7 KS03 R Typical Guestroom Plan  
SCALE: 1/4" = 1'-0"

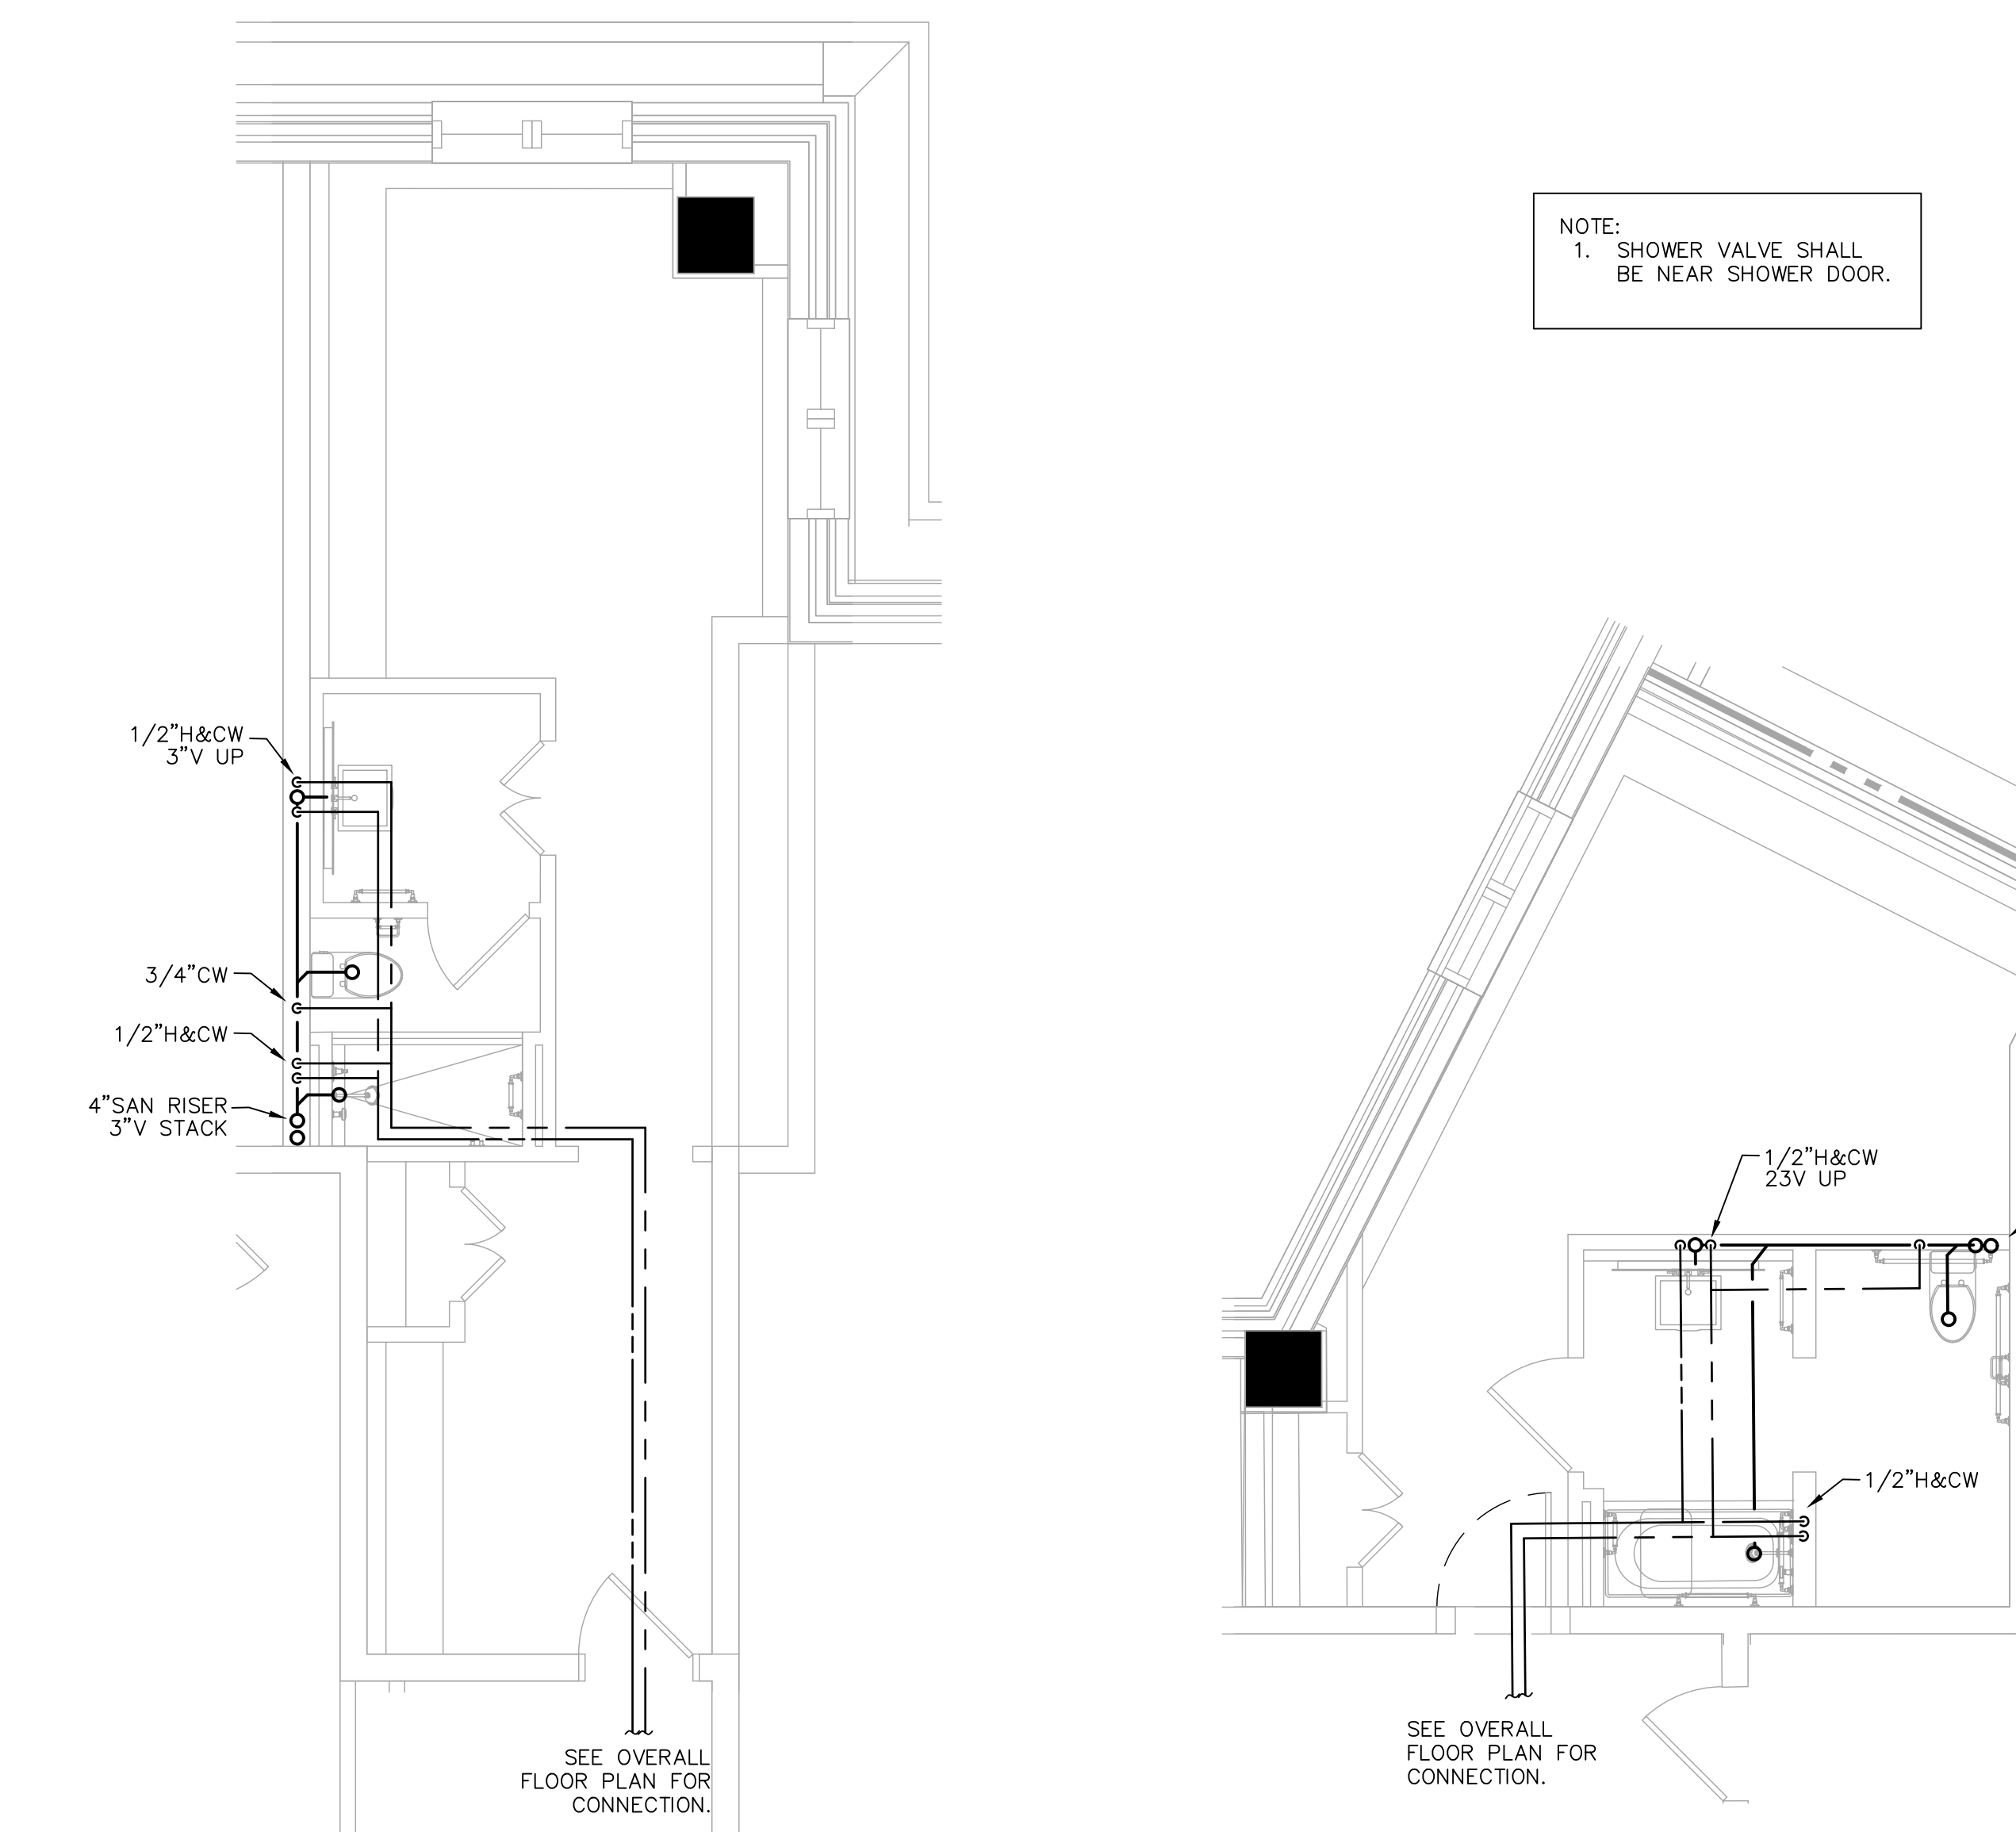

8 KJ02 R Typical Guestroom Plan  
SCALE: 1/4" = 1'-0"

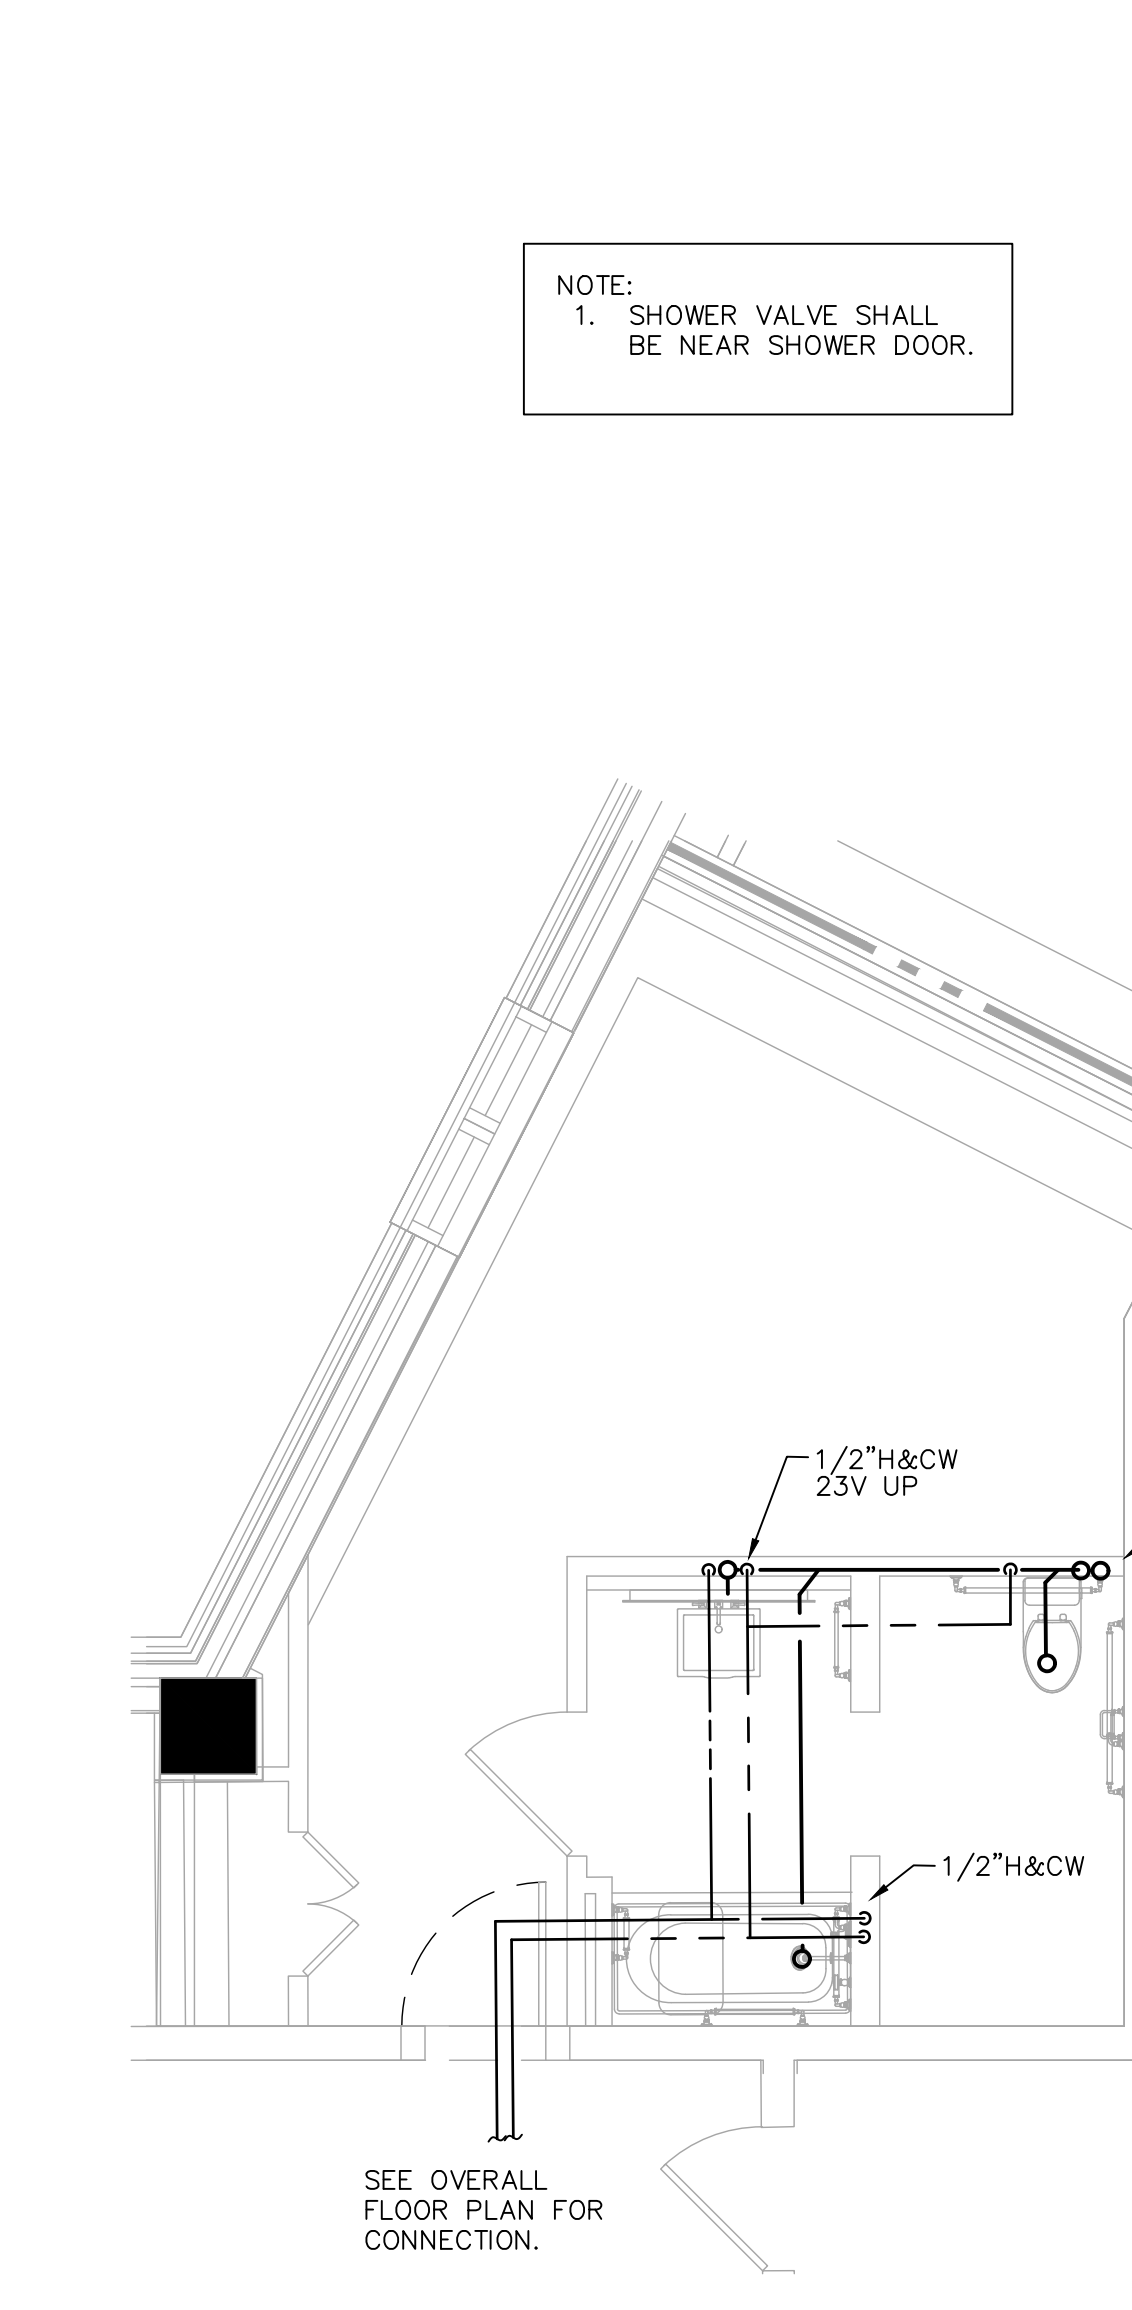


9 ACC K04 R Typical Guestroom Plan  
SCALE: 1/4" = 1'-0"

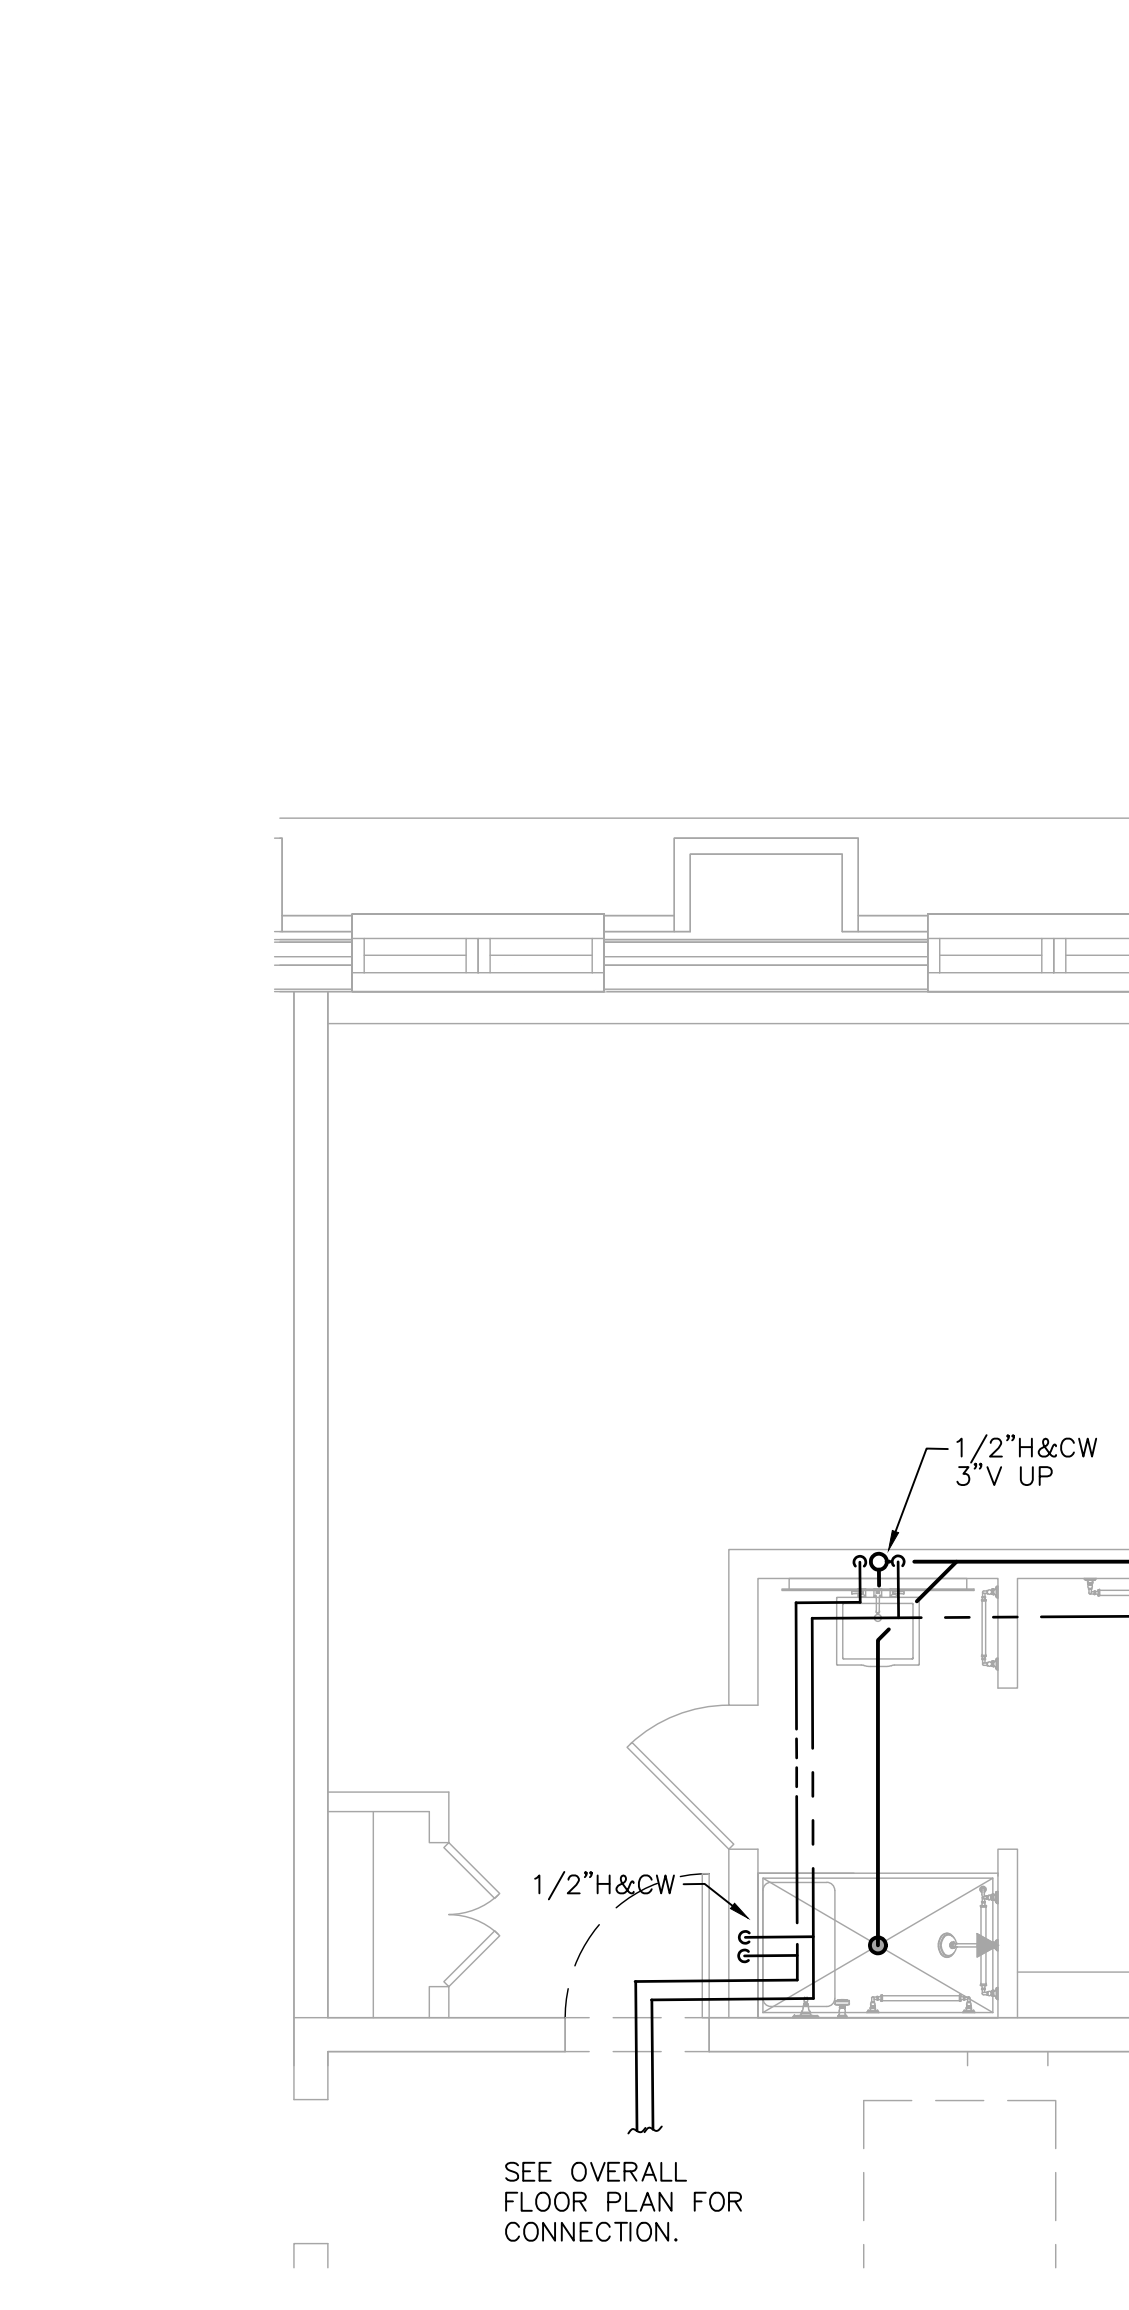

10 ACC K08 L Typical Guestroom Plan  
SCALE: 1/4" = 1'-0"

NOTE:  
1. SHOWER VALVE SHALL  
BE NEAR SHOWER DOOR.

STIPULATION FOR REUSE:  
THIS DRAWING WAS PREPARED FOR USE ON A SPECIFIC SITE AT DULUTH, GA CONTEMPORANEOUSLY WITH ITS ISSUE DATE AS NOTED BELOW, AND IT IS NOT SUITABLE FOR USE ON A DIFFERENT PROJECT SITE OR AT A LATER TIME. USE OF THIS DRAWING FOR REFERENCE OR EXAMPLE ON ANOTHER PROJECT REQUIRES THE SERVICES OF PROPERLY LICENSED ARCHITECTS AND ENGINEERS. REPRODUCTION OF THIS DRAWING FOR REUSE ON ANOTHER PROJECT IS NOT AUTHORIZED AND MAY BE CONTRARY TO THE LAW.

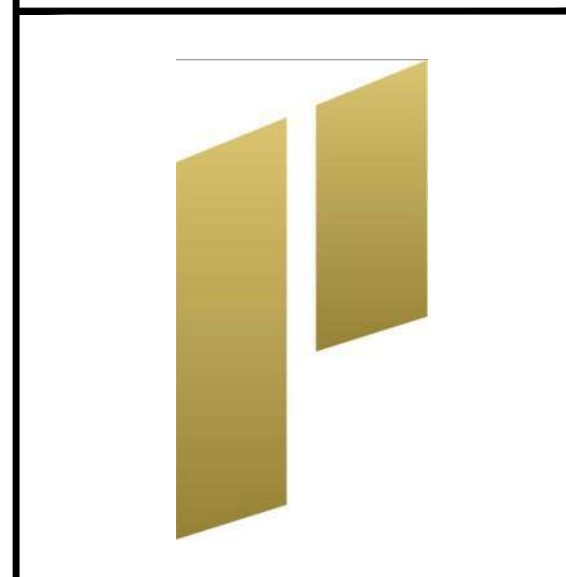

CONSULTANTS:  
**Beach Engineering Solutions Team**  
Mechanical, Electrical & Plumbing Engineering  
(678) 665-3280  
Project Number: 23-547

**THE STRICKLANDER**  
MARRIOTT AUTOGRAPH  
GUESTROOMS  
6405 SUGARLOAF PARKWAY  
DULUTH, GEORGIA 30097



ISSUE BLOCK:

1	REV 1	11.22.2024
2	REV 2	04.07.2025
3	REV 3	04.18.2025
4	REV 4	05.28.2025
5	REV 5	04.02.2026

DOCUMENT DATE:	04/02/26
DRAWN BY:	CL/YC
CHECKED BY:	BGB
PROJECT NO.:	JHD-024-NA-100001
SHEET TITLE:	

**PLUMBING UNIT  
FLOOR PLAN 3**

SHEET NUMBER:  
**P-203**